


Revision	Issue Date	Dm	Chk

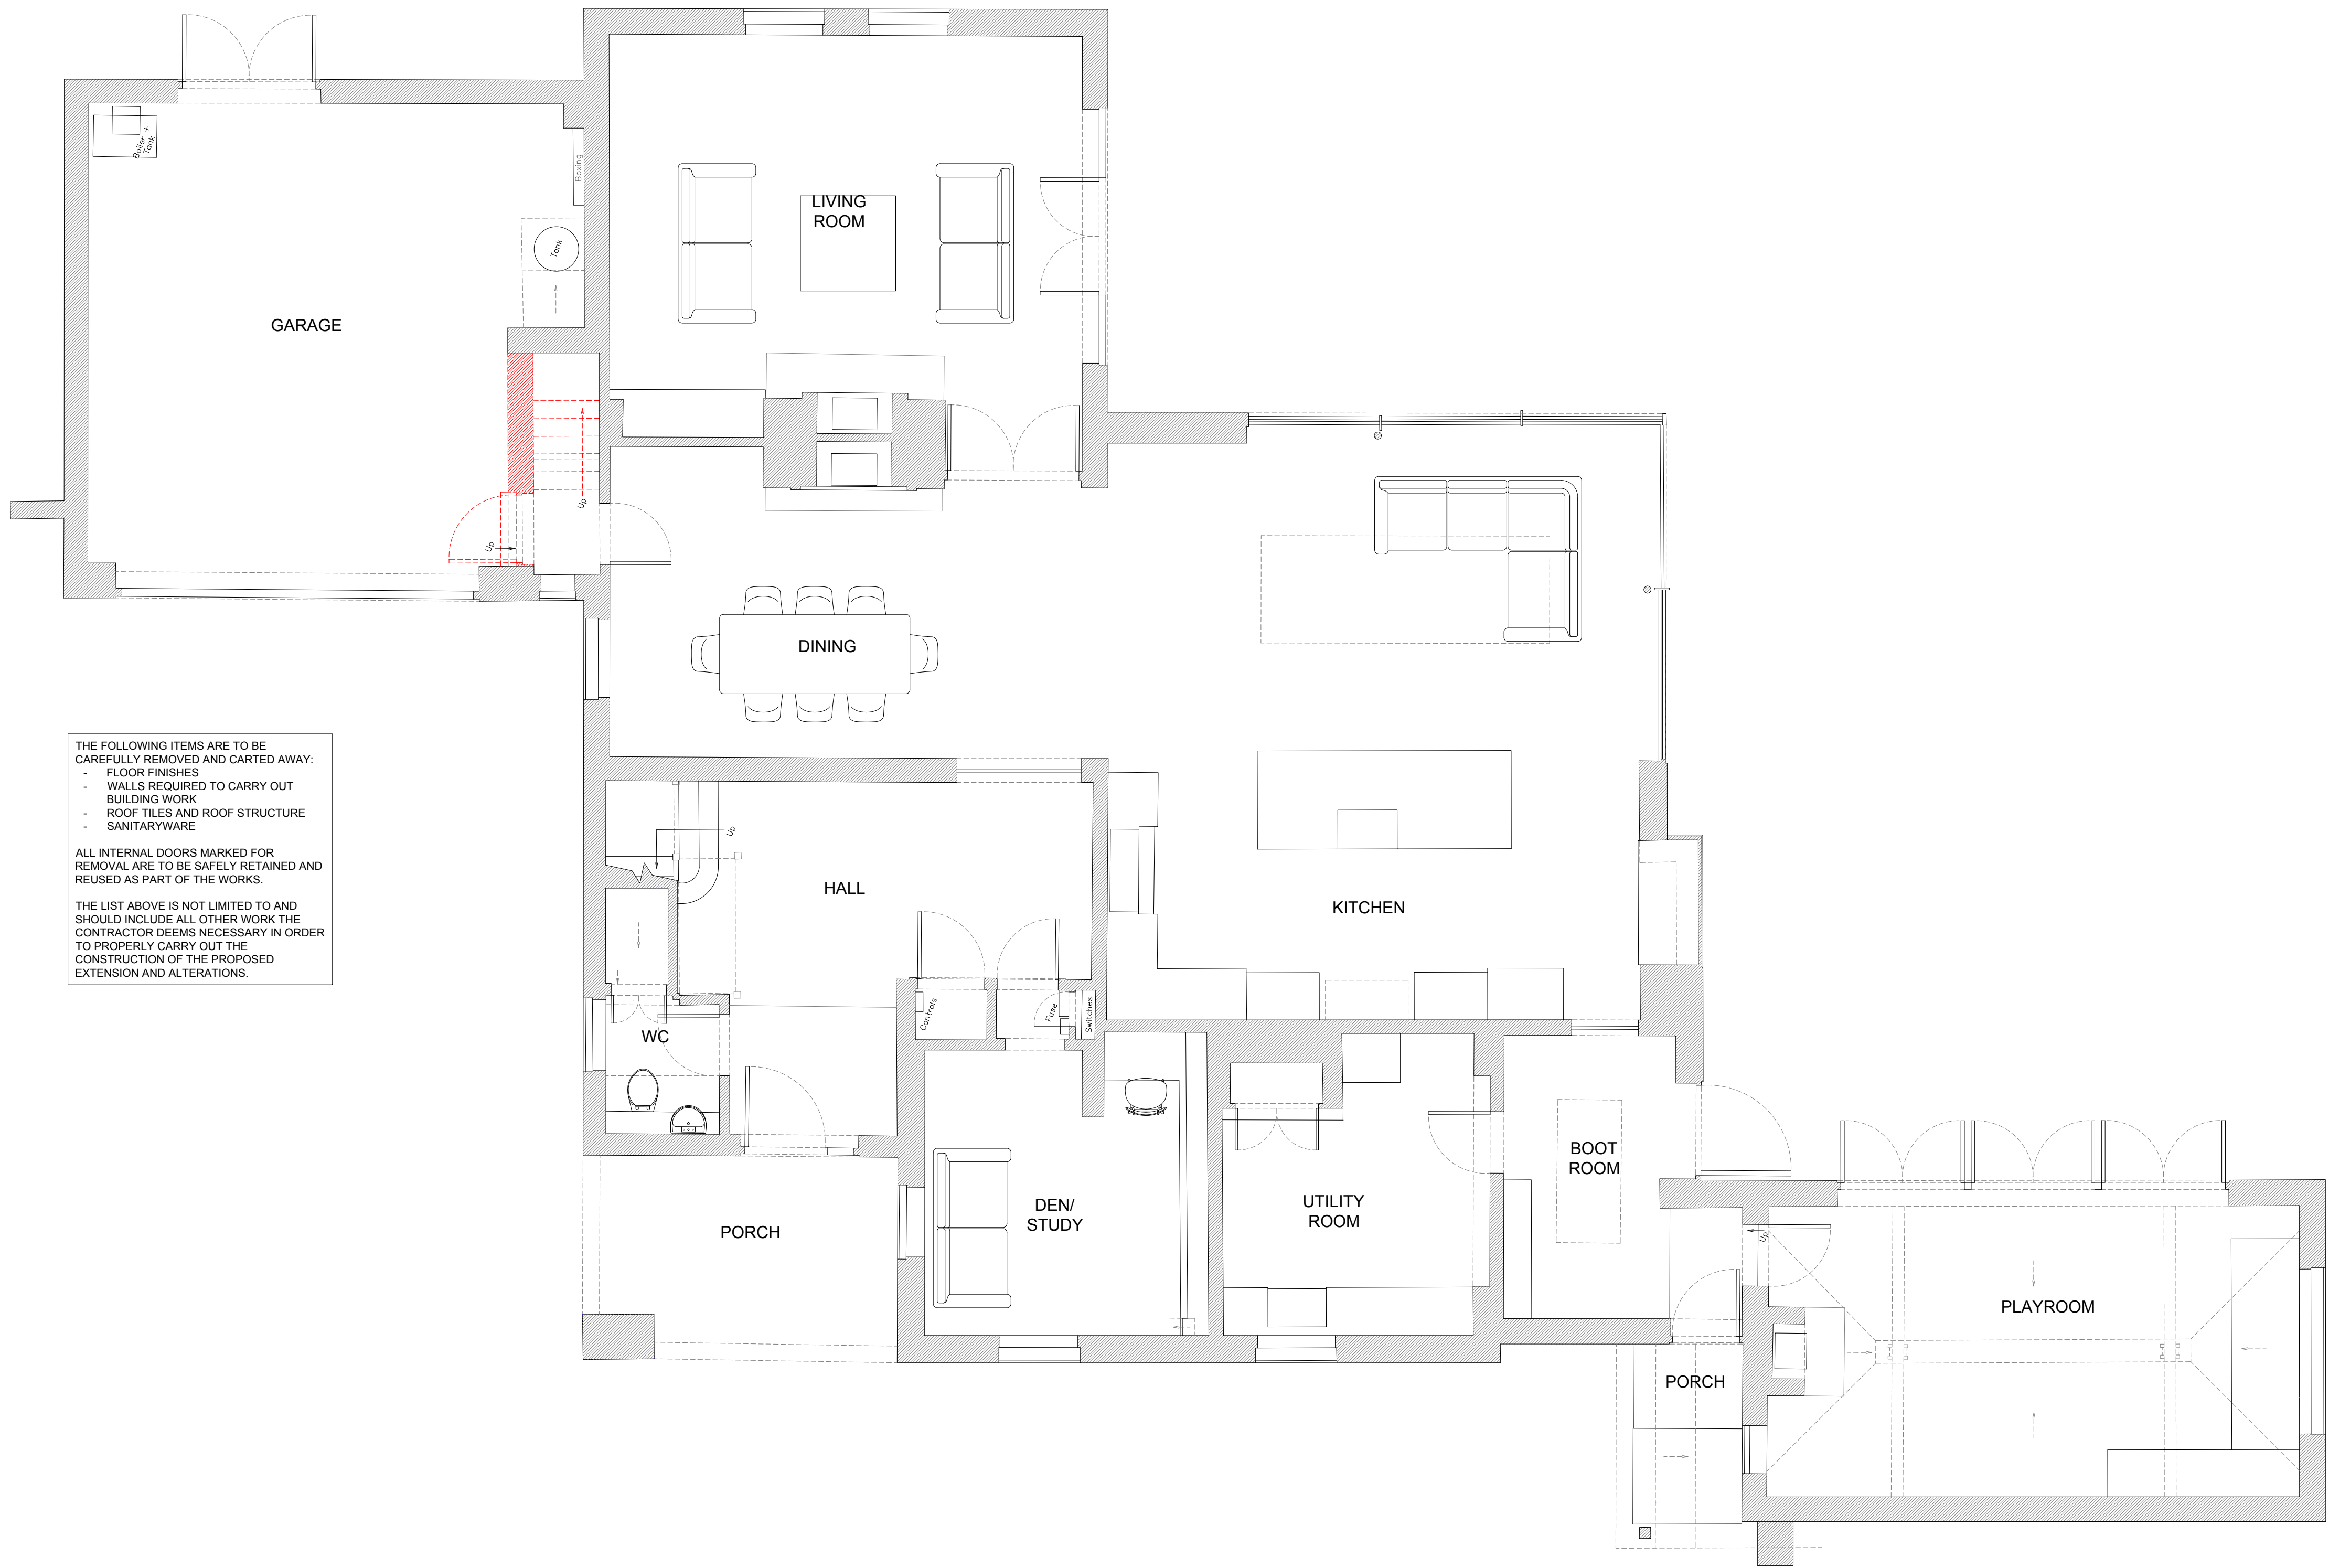

THE FOLLOWING ITEMS ARE TO BE CAREFULLY REMOVED AND CARTED AWAY:

- FLOOR FINISHES
- WALLS REQUIRED TO CARRY OUT BUILDING WORK
- ROOF TILES AND ROOF STRUCTURE
- SANITARYWARE

ALL INTERNAL DOORS MARKED FOR REMOVAL ARE TO BE SAFELY RETAINED AND REUSED AS PART OF THE WORKS.

THE LIST ABOVE IS NOT LIMITED TO AND SHOULD INCLUDE ALL OTHER WORK THE CONTRACTOR DEEMS NECESSARY IN ORDER TO PROPERLY CARRY OUT THE CONSTRUCTION OF THE PROPOSED EXTENSION AND ALTERATIONS.

GENERAL NOTES - DEMOLITION

1. THIS DRAWING IS TO BE READ IN CONJUNCTION WITH ALL GENERAL ARRANGEMENT, PROJECT DETAILS, SPECIFICATIONS AND CONSULTANTS DRAWINGS.
2. UNLESS NOTED OTHERWISE, ALL DIMENSIONS ARE TO STRUCTURAL FACES AND/OR PARTITION STUDS.
4. LEGEND

DEMOLITION WORKS

Status
BUILDING CONTROL


Project
NORTH COTTAGE, READING ROAD,
GORING RG8 0LL

Drawing Title
EXISTING GROUND FLOOR PLAN


Date	Scale	Drawn by	Check by
JUNE 22	1:50 @ A1	CA	KB
Project No.	Drawing No.	Revision	
22.134	GA.1300	-	

Fineline
Architects

T. 07825 615 255
E. info@finelinearchitects.co.uk
W. www.finelinearchitects.co.uk

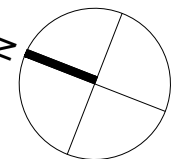

SCALE 1:50
0 1 2 3 4 5 (M.)

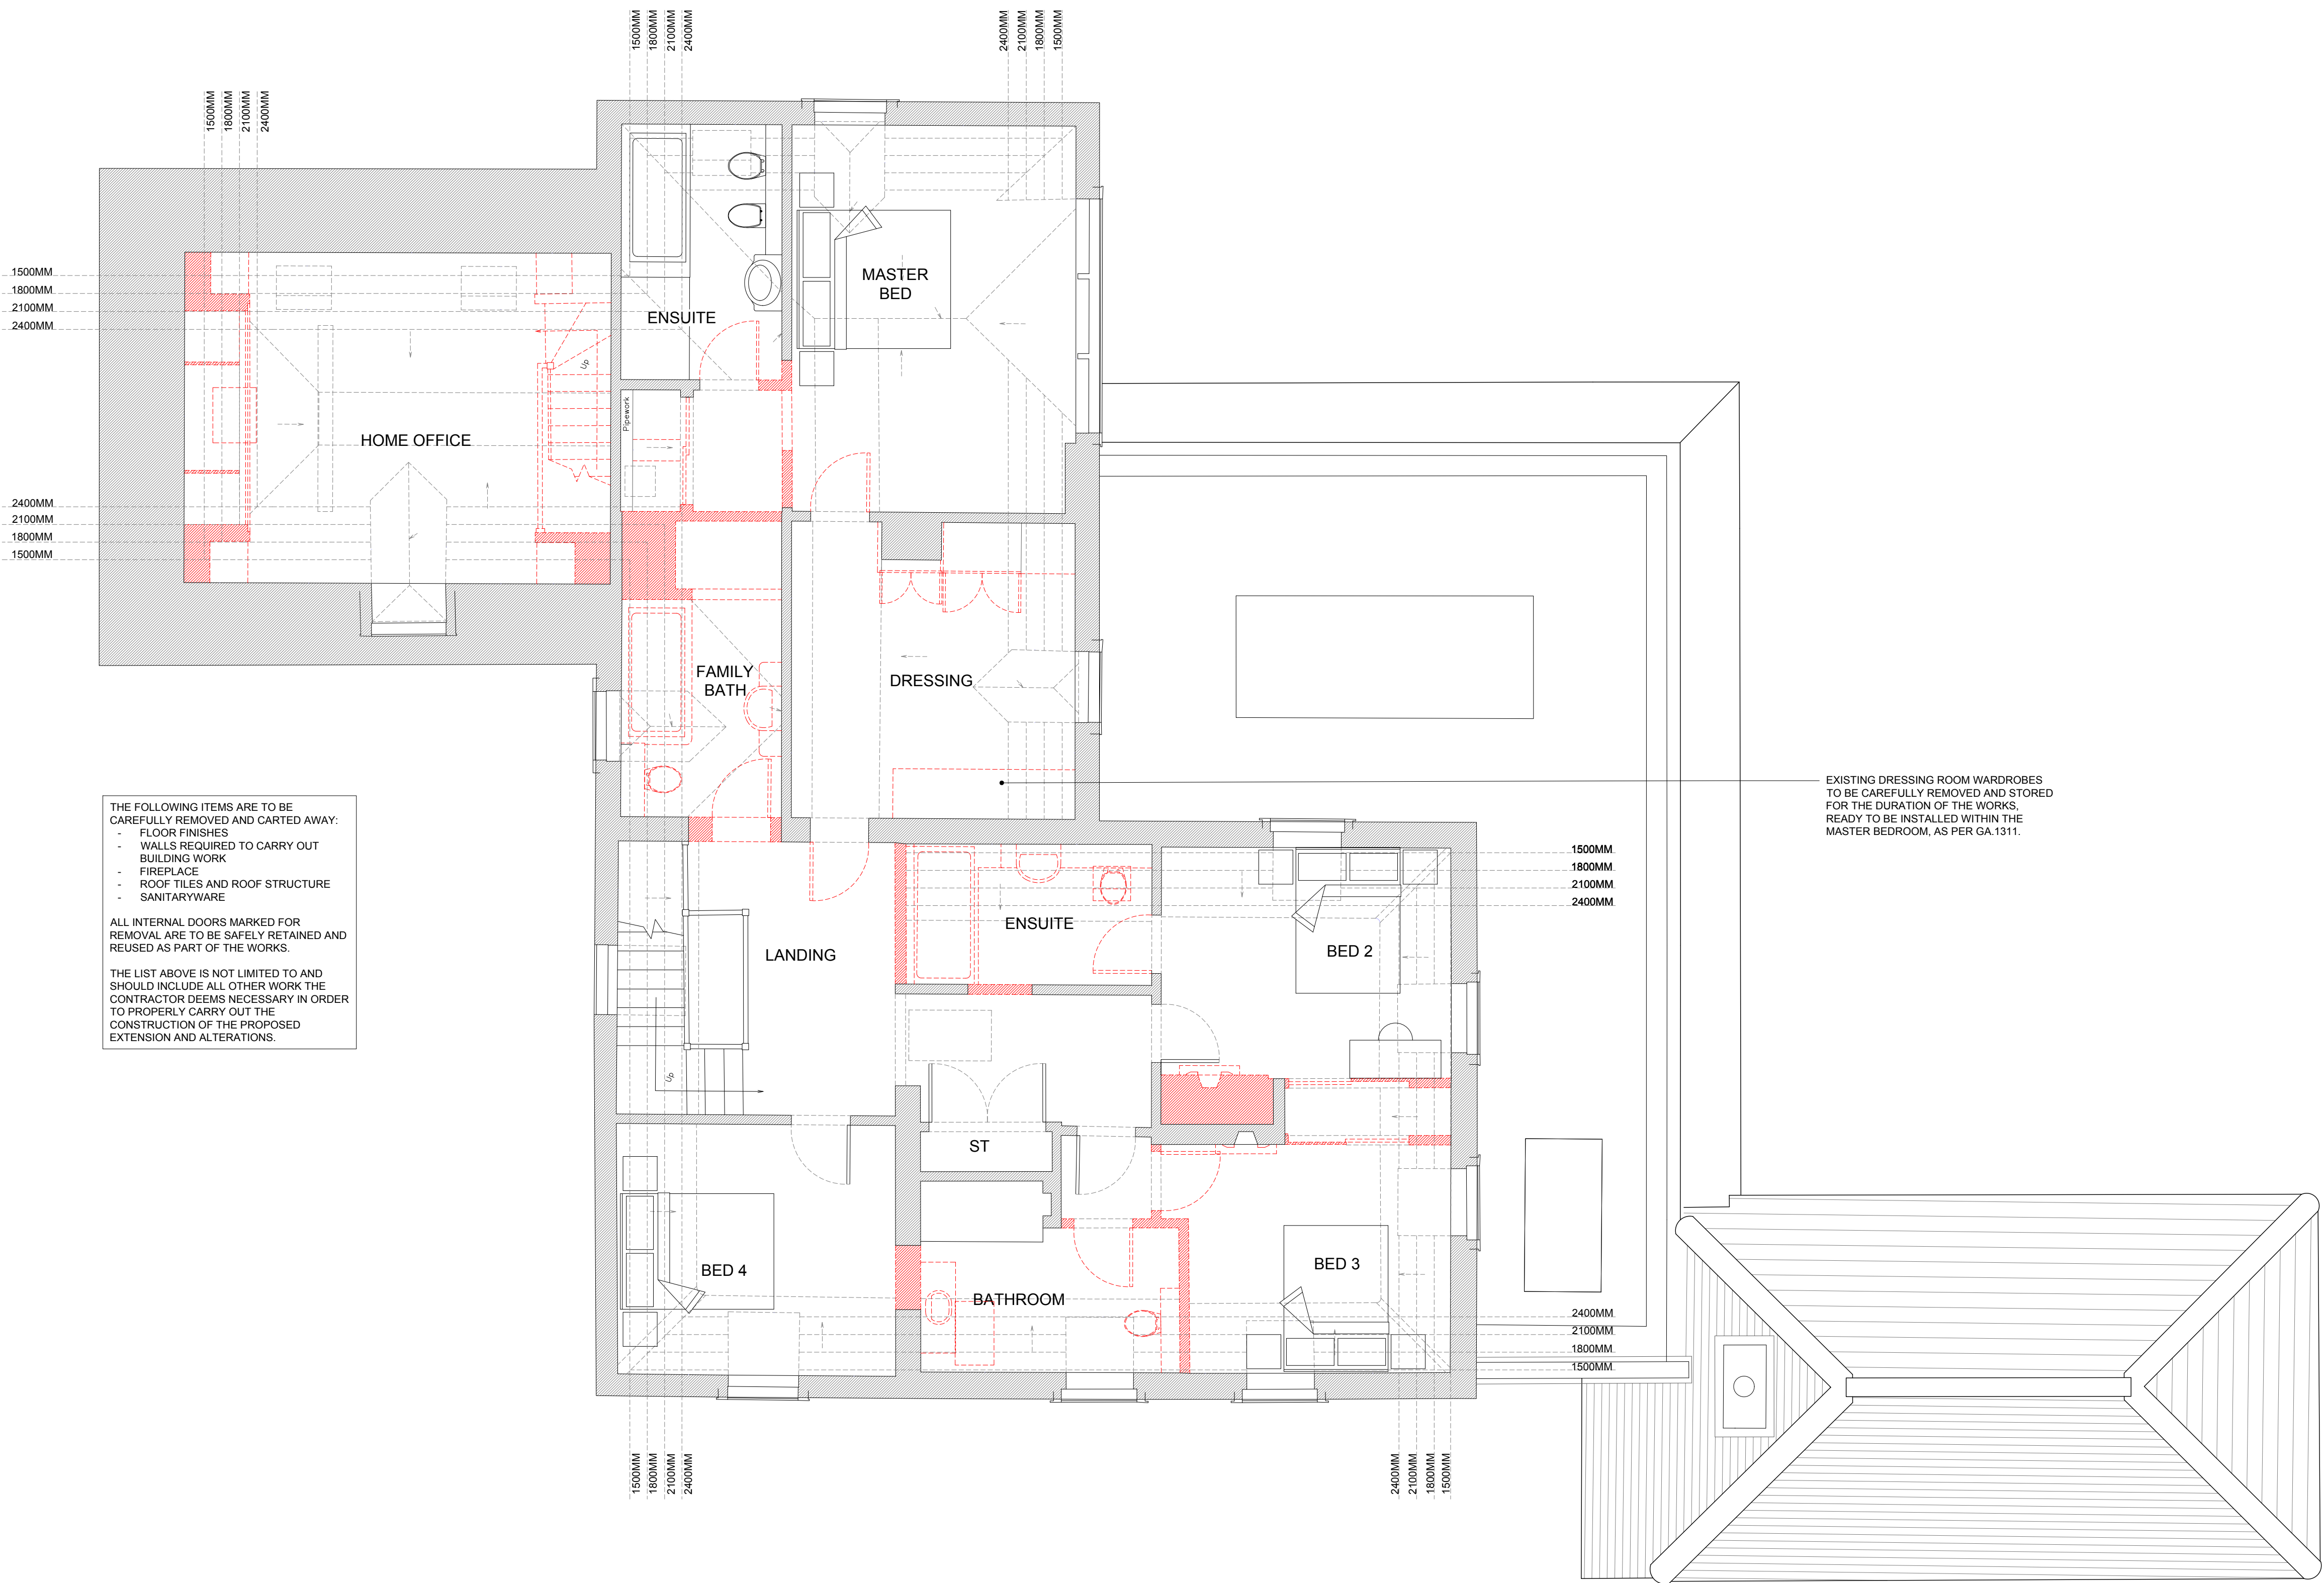

EXISTING FIRST FLOOR PLAN

GENERAL NOTES - DEMOLITION

- THIS DRAWING IS TO BE READ IN CONJUNCTION WITH ALL GENERAL ARRANGEMENT, PROJECT DETAILS, SPECIFICATIONS AND CONSULTANTS DRAWINGS.
- UNLESS NOTED OTHERWISE, ALL DIMENSIONS ARE TO STRUCTURAL FACES AND/OR PARTITION STUDS.
- LEGEND

DEMOLITION WORKS

BUILDING CONTROL


Project
NORTH COTTAGE, READING ROAD,
GORING RG8 0LL

Drawing Title
EXISTING FIRST FLOOR PLAN

Date	Scale	Drawn by	Check by
JUNE 22	1:50 @ A1	CA	KB
Project No.	Drawing No.	Revision	
22.134	GA.1301	-	

Fineline
Architects

Revision	Issue Date	Dm	Chk

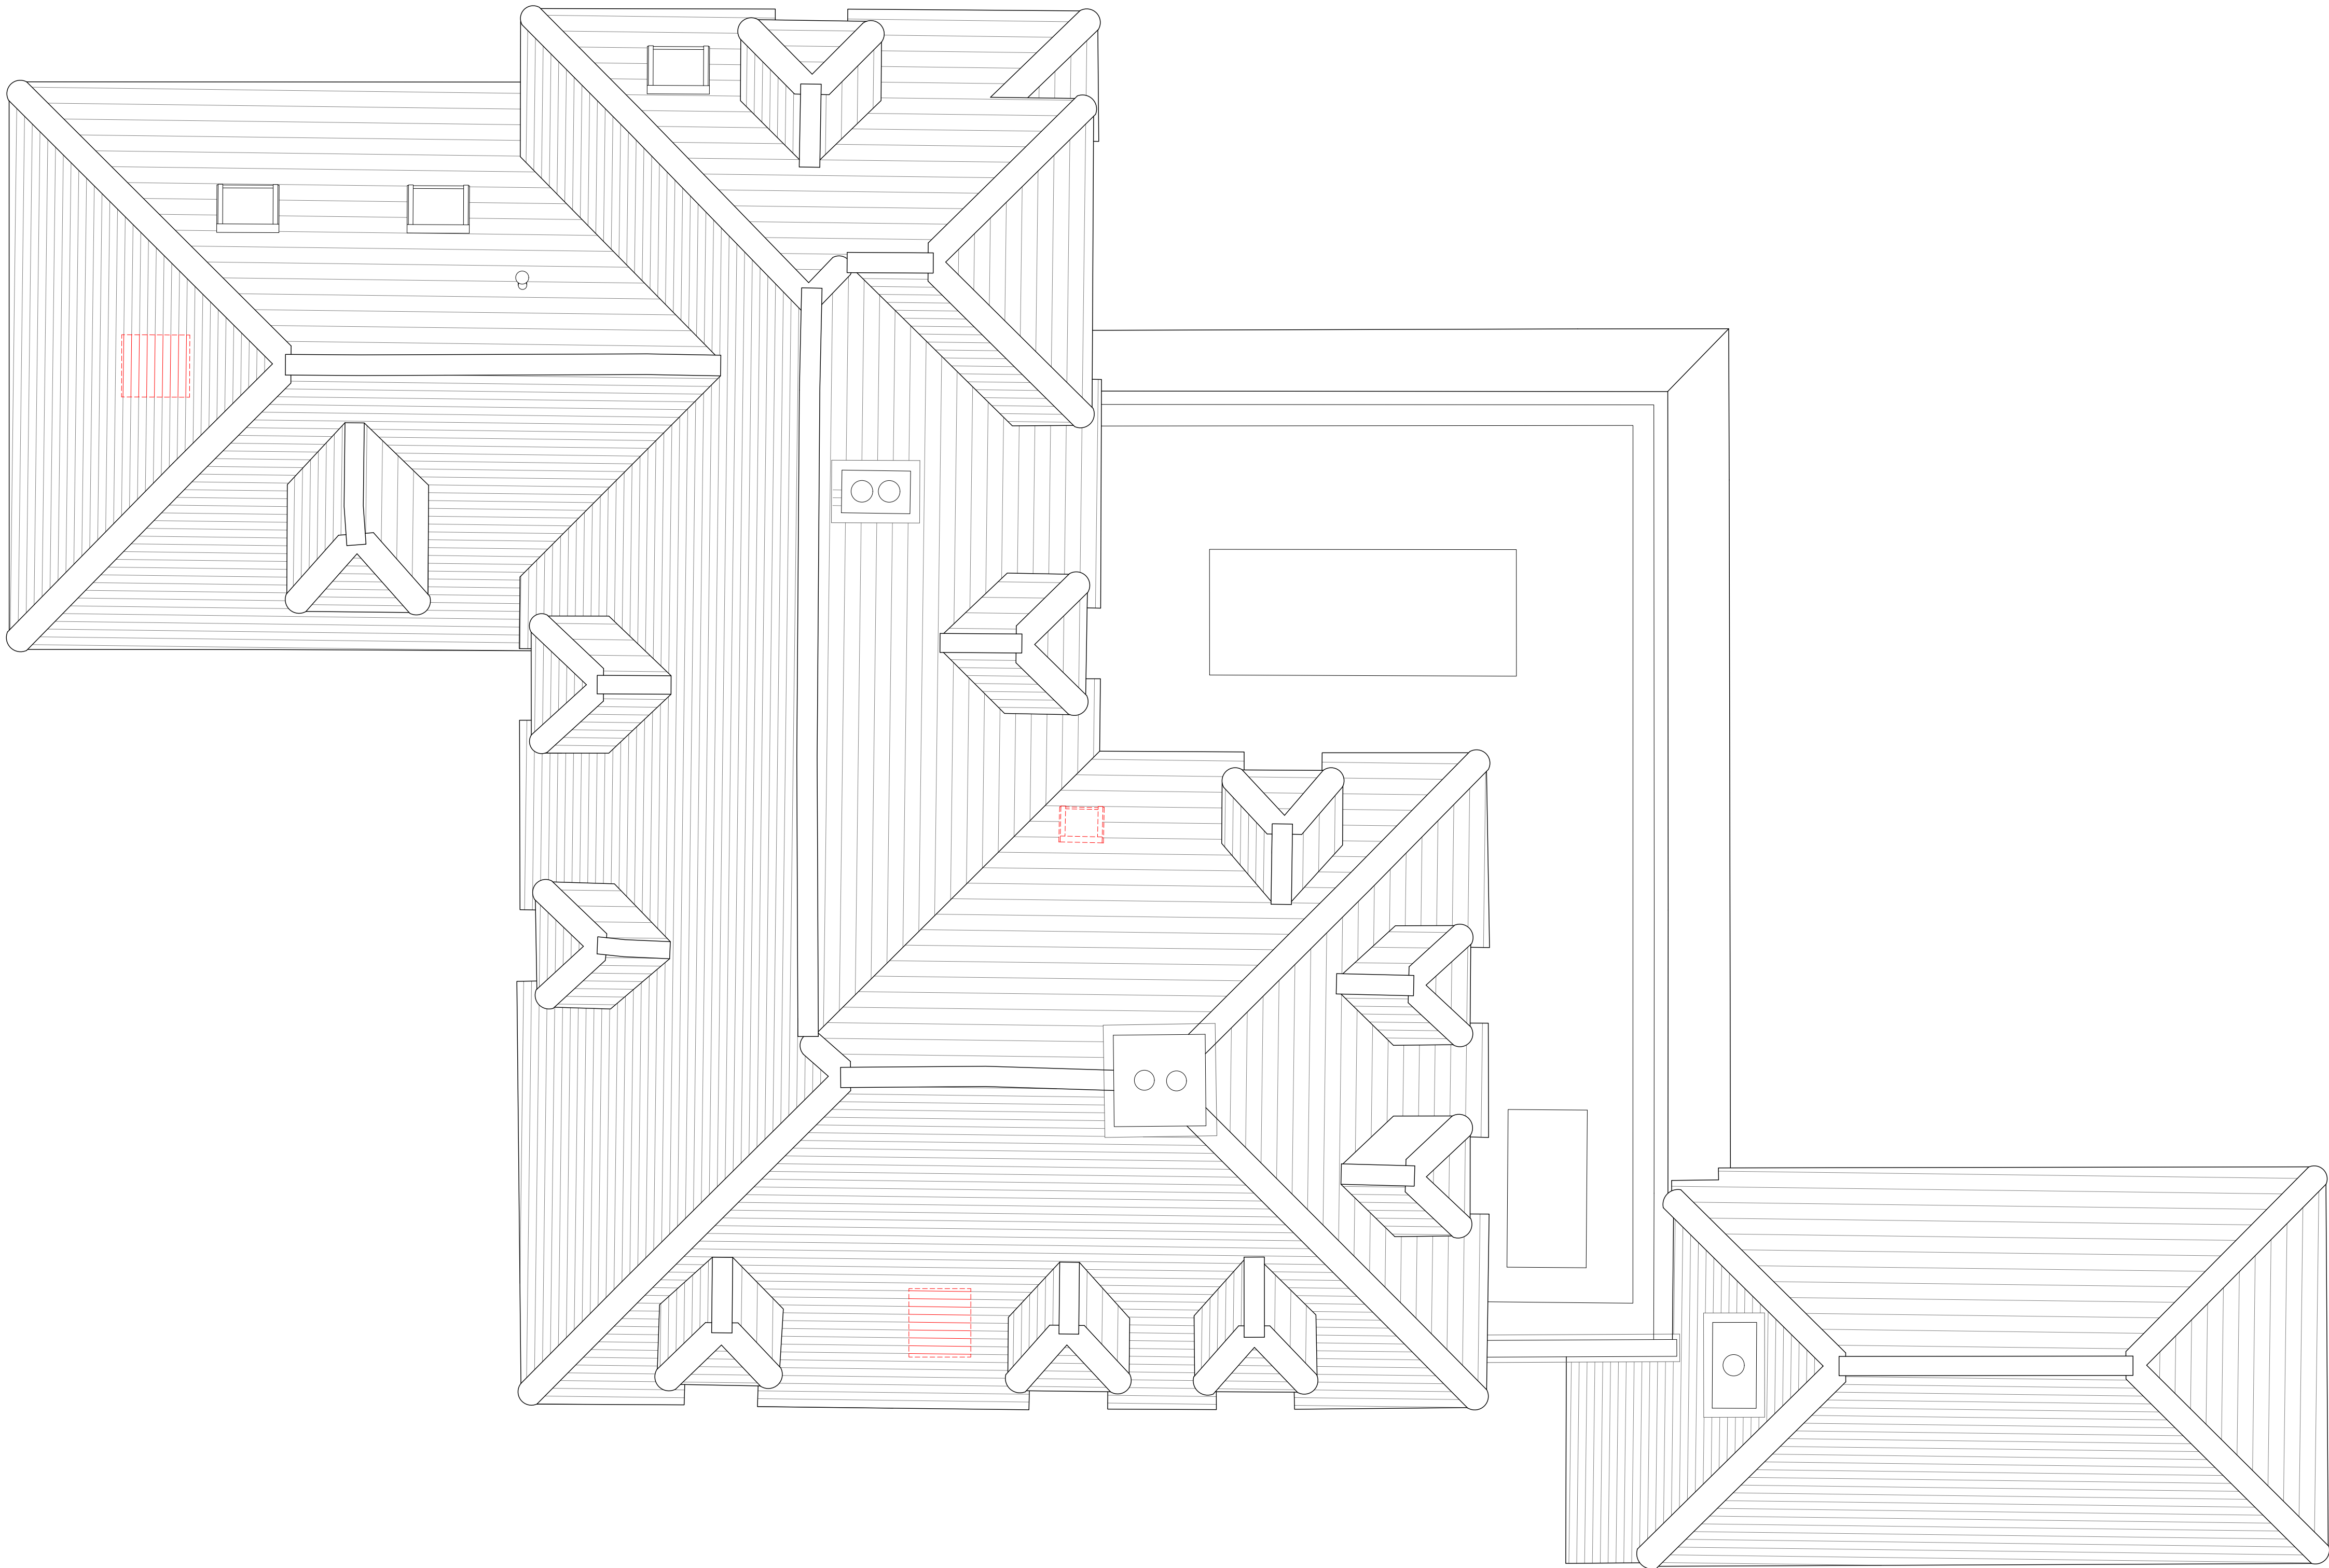

EXISTING ROOF PLAN

GENERAL NOTES - DEMOLITION

- THIS DRAWING IS TO BE READ IN CONJUNCTION WITH ALL GENERAL ARRANGEMENT, PROJECT DETAILS, SPECIFICATIONS AND CONSULTANTS DRAWINGS.
- UNLESS NOTED OTHERWISE, ALL DIMENSIONS ARE TO STRUCTURAL FACES AND/OR PARTITION STUDS.
- LEGEND

DEMOLITION WORKS


Status
BUILDING CONTROL

Project
NORTH COTTAGE, READING ROAD,
GORING RG8 0LL
Drawing Title
EXISTING ROOF PLAN


Date	Scale	Drawn by	Check by
JUNE 22	1:50 @ A1	CA	KB
Project No.	Drawing No.	Revision	
22.134	GA.1302	-	

Fineline
Architects


T. 07825 615 255
E. info@finelinearchitects.co.uk
W. www.finelinearchitects.co.uk

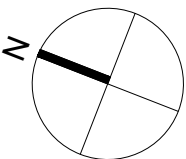

SCALE 1:50
0 1 2 3 4 5 (M.)

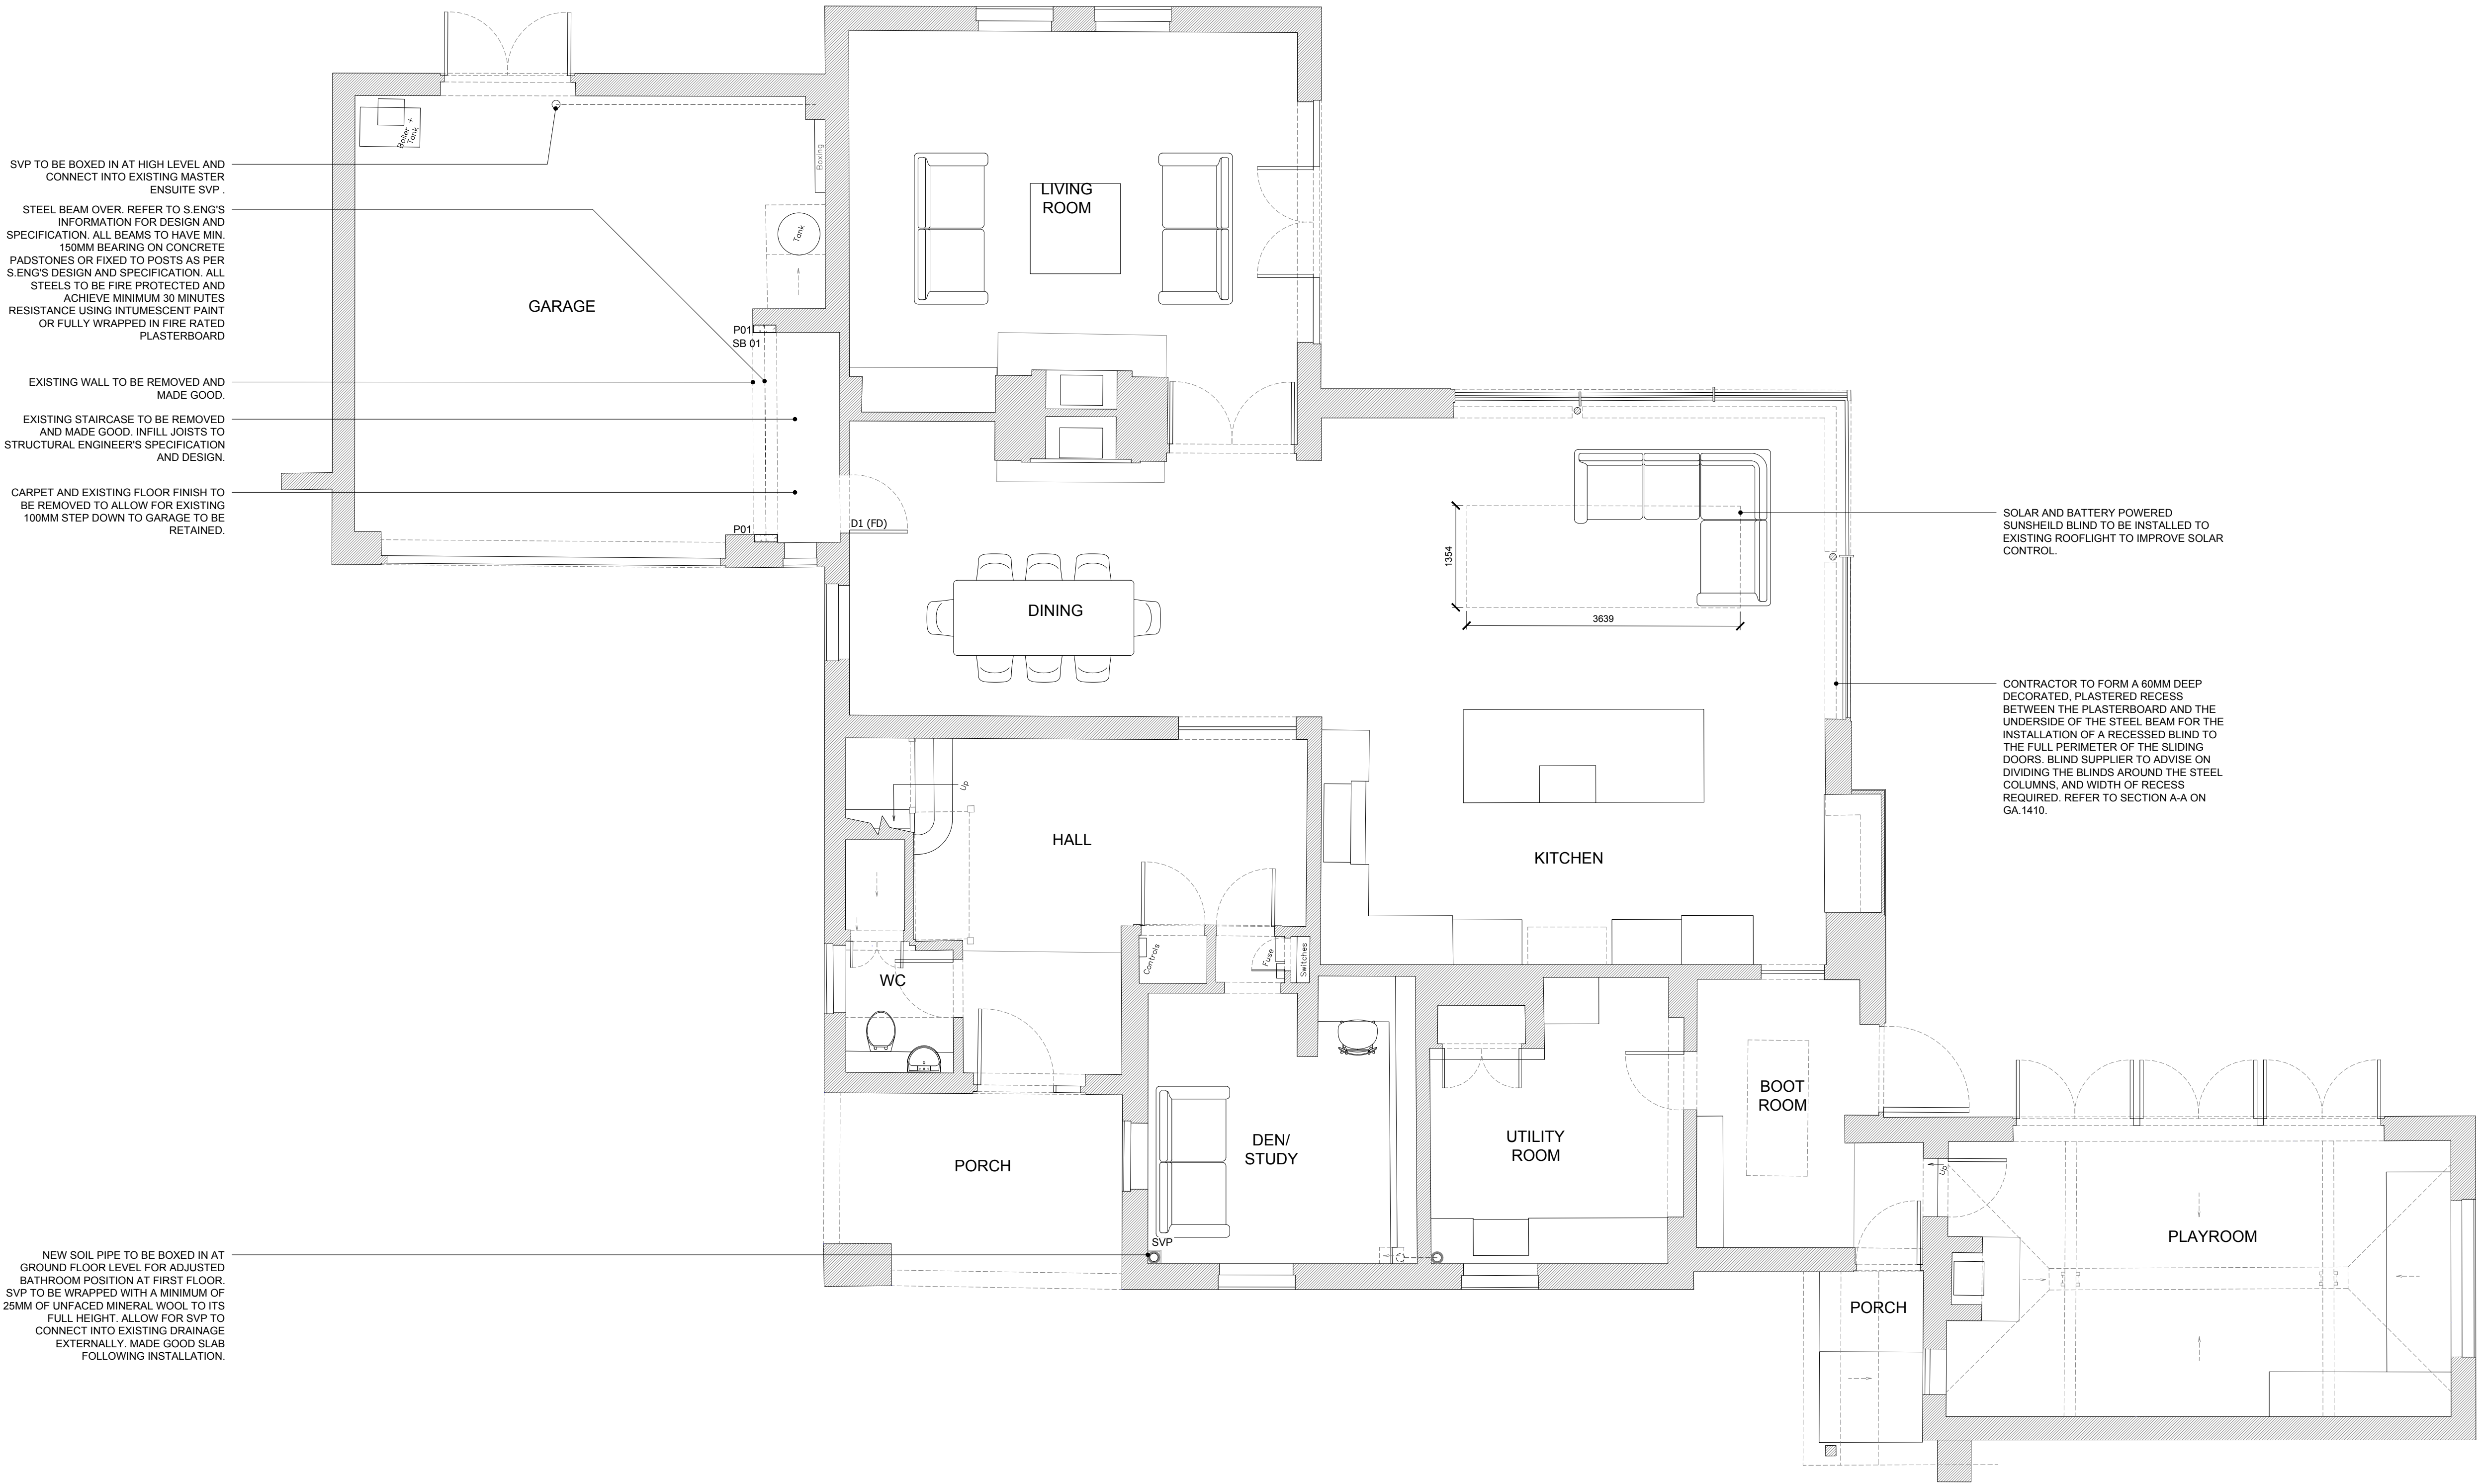

PROPOSED GROUND FLOOR PLAN

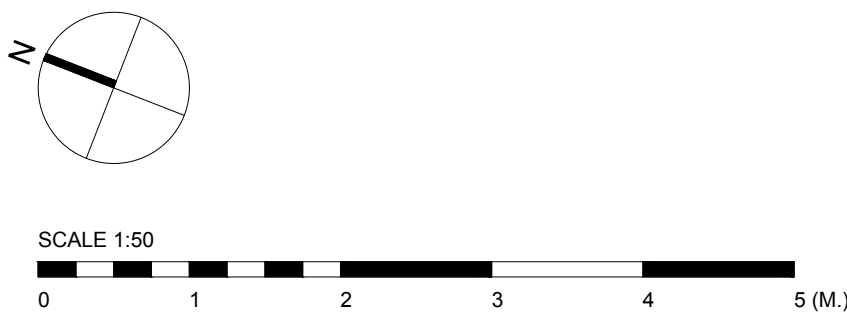

INTERNAL DOOR & ROOFLIGHT SCHEDULE - FIRST FLOOR				
	DOOR LEAF	ROOM NAME	EXISTING OPENING	NOTES
D1 (FD)	TO MATCH EXISTING	DINING/GARAGE	YES	REPLACEMENT DOOR TO EXISTING OPENING WITH FIRE RATED DOOR. CONTRACTOR TO ALLOW TO INSTALL AND DECORATE DOOR AND INSTALL FIRE RATED IRONMONGERY, SELF CLOSER AND SMOKE AND INTUMESCENT SEALS TO BE INSTALLED.
NOT ES	REFERENCES FOR OPENINGS:- D= INTERNAL DOOR , FD= FIRE DOOR FOR 20 MIN. ALLOW 10MM AIR GAP UNDER DOORS TO ALL ROOMS EXCEPT STORE AREAS STRUCTURAL OPENING SIZES BASED ON LEAF SIZE + 42X2 DOOR FRAME. STRUCTURAL OPENINGS WILL VARY FOR ANY OTHER DOOR FRAME SIZE. DOOR HEIGHTS ASSUME CARPET FINISH. ALTERNATIVE FINISHES MAY AFFECT DOOR SETTING OUT.			

Copyright Fineline Architects Ltd. This drawing, or any of its contents, may not be copied, reproduced or distributed without the written consent of Fineline Architects. Do not scale off this drawing. Figured dimensions to be taken from this drawing only. All contractors, subcontractors and/or specialists are responsible for taking and checking all dimensions relating to their work on site. This drawing is to be read in conjunction with all consultants information.

Revision	Issue Date	Dm	Chk

GENERAL NOTES - FLOOR PLANS

- THIS DRAWING IS TO BE READ IN CONJUNCTION WITH ALL GENERAL ARRANGEMENT, PROJECT DETAILS, SPECIFICATIONS AND CONSULTANTS DRAWINGS.
- UNLESS NOTED OTHERWISE, ALL DIMENSIONS ARE TO STRUCTURAL FACES AND/OR PARTITION STUDS.
- ABBREVIATIONS:
MJ MOVEMENT JOINT
HL AT HIGH LEVEL
AAV AIR ADMITTANCE VALVE
SVP SOIL AND VENT PIPE
DP DRAINAGE POINT
RWP RAIN WATER PIPE
J JOISTS
T TRUSS
SB STRUCTURAL BEAM
- LEGEND
EXTERNAL WALLS:
EXISTING WALL
FACING BRICKWORK
BLOCKWORK. BLOCK STRENGTH TO BE IN ACCORDANCE WITH THE STRUCTURAL ENGINEERS DETAILS
NON-LOADBEARING PARTITION:
50X75MM CLS TIMBER STUDS AT MAX. 450MM CENTRES WITH 12.5MM B.G. GYPROC WALL BOARD TO EACH SIDE. ALL INTERNAL WALLS TO BE FILLED WITH 75MM ROCKWOOL INSULATION TO ACHIEVE MIN. 40DB SOUND REDUCTION
15MM PLYWOOD PATTERESSING AND MOISTURE RESISTANT BOARD TO BE USED IN ALL BATHROOMS, KITCHENS AND EN-SUITE WET AREAS (GREEN BOARDS)
DENOTES SPAN OF FLOOR JOISTS OVER
PADSTONE (REFER TO S.E. INFORMATION FOR SPECIFICATION)
- FOR ALL STRUCTURAL STEELWORK, PADSTONES, AND MOVEMENT JOINT DETAILS REFER TO THE STRUCTURAL ENGINEER'S DRAWINGS AND DETAILS.
- ALL DRAINAGE RUNS TO BE ABOVE FLOOR UNLESS STATED OTHERWISE.
- ALL KITCHEN LAYOUTS TO SPECIALIST'S DESIGN AND DETAILS
- ALL EXTRACT DUCTS TO BE WITHIN THE FLOOR / ROOF SPACE UNLESS NOTED OTHERWISE.
- AIRFLOW AIRFLOW QT120T VENTILATION EXTRACT
- SMOKE ALARM - TO BE SELF CONTAINED, MAINS FED & INTERCONNECTED, TO COMPLY WITH B.S. 5446 PART 1.
- HEAT DETECTOR A100 EI 144 WITH BATTERY BACK UP
- ALL ELEMENTS OF WORK TO BE INSTALLED ACCORDING TO THE APPROPRIATE MANUFACTURER'S INSTRUCTIONS.

Status
BUILDING CONTROL


Project
NORTH COTTAGE, READING ROAD,
GORING RG8 0LL
Drawing Title
PROPOSED GROUND FLOOR PLAN

Date	Scale	Drawn by	Check by
JUNE 22	1:50 @ A1	CA	KB
Project No.	Drawing No.	Revision	
22.134	GA.1310	-	

Fineline
Architects

T. 07825 615 255
E. info@finelinearchitects.co.uk
W. www.finelinearchitects.co.uk

FINISHES SCHEDULE	
ROOM	FINISH
WALLS AND CEILINGS	JOHNSTONES TO MATCH FARROW AND BALL TO ALL AFFECTED AREAS. JOHNSTONES KITCHEN AND BATHROOM EMULSION TO BE APPLIED TO BATHROOMS.
FIRST FLOOR	CARPET TO BE SUPPLIED AND INSTALLED BY CLIENT APPOINTED SUPPLIER, EXCEPT BATHROOMS.
BATHROOMS	CONTRACTOR TO ALLOW TO INSTALL CLIENT SUPPLY SANITARYWARE TO ALL AFFECTED FIRST FLOOR BATHROOMS. REFER TO BATHROOM ELEVATIONS FOR TILE EXTENTS. CONTRACTOR TO ALLOW TO INSTALL CLIENT SUPPLY TILES TO ALL AREAS INDICATED.
SKIRTING AND ARCHITRAVES	MDF PAINTED SKIRTING TO MATCH EXISTING IN JOHNSTONES EGGSHELL TO MATCH FARROW AND BALL (COLOUR TBA). MDF PAINTED ARCHITRAVE TO MATCH EXISTING IN JOHNSTONES EGGSHELL TO MATCH FARROW AND BALL (COLOUR TBA).

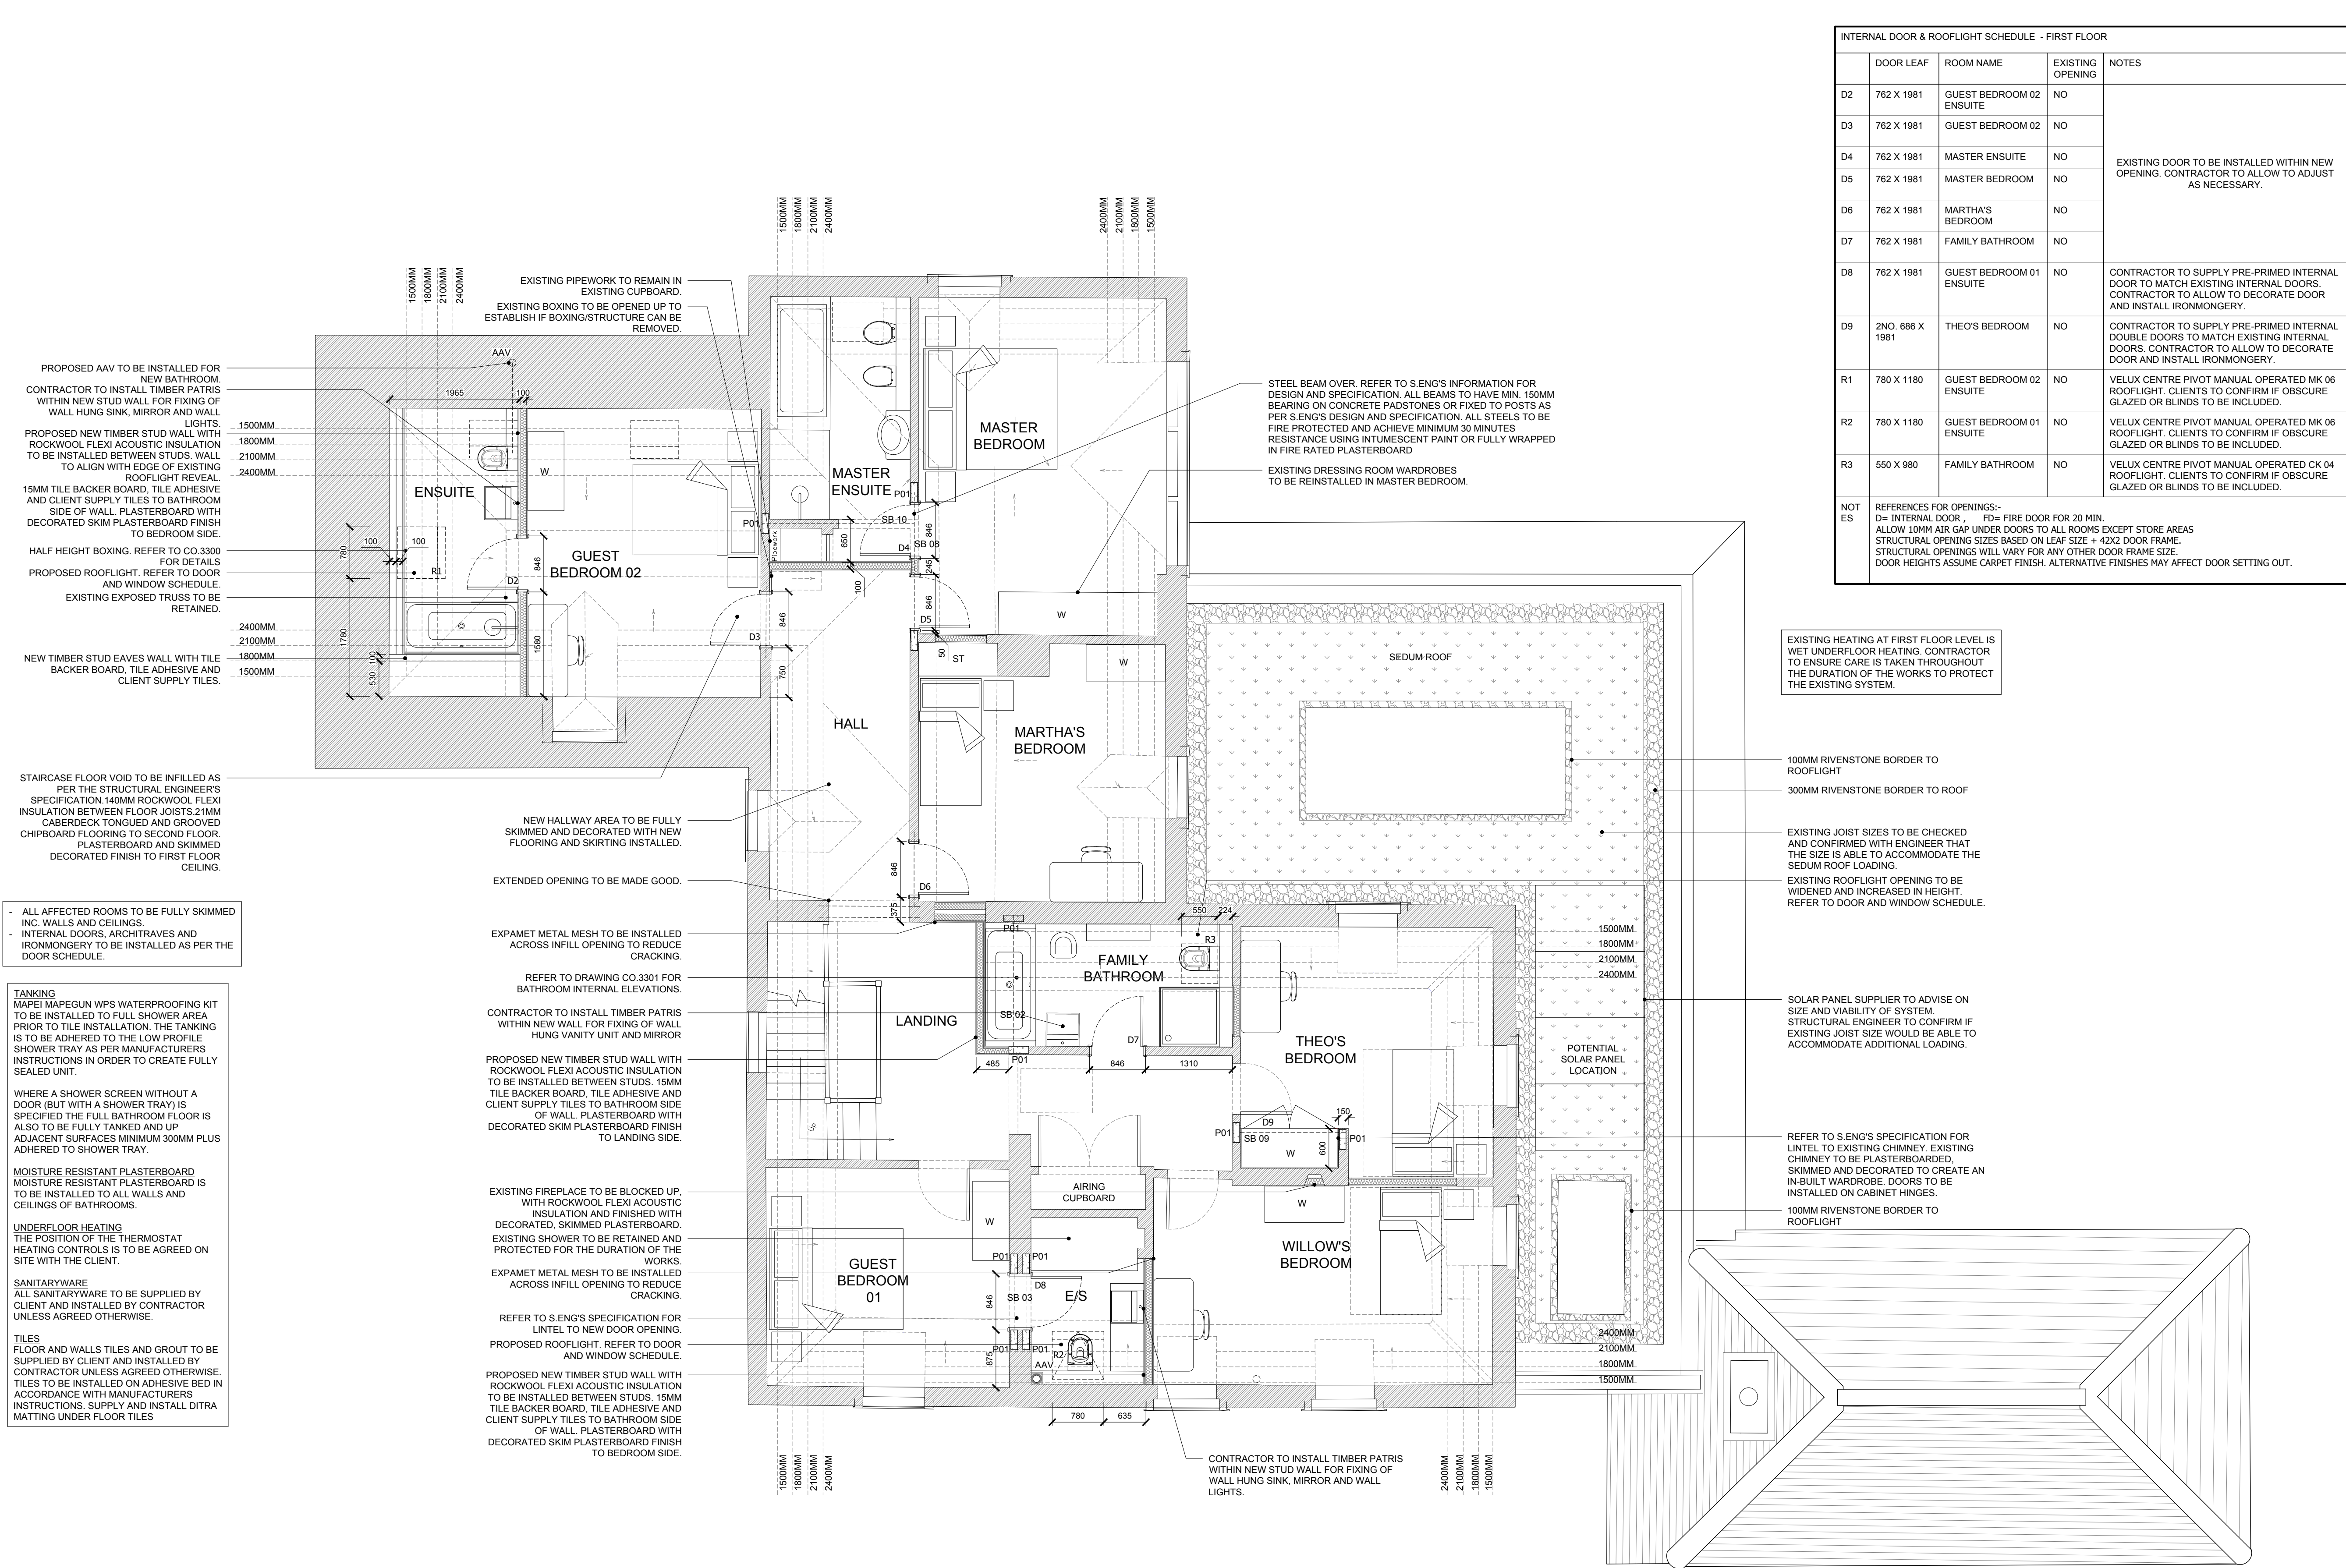

Copyright Fineline Architects Ltd. This drawing, or any of its contents, may not be copied, reproduced or distributed without the written consent of Fineline Architects. Do not scale off this drawing. Figured dimensions to be taken from this drawing only. All contractors, subcontractors and/or specialists are responsible for taking and checking all dimensions relating to their work on site. This drawing is to be read in conjunction with all consultants information.

Revision Issue Date Dm Chk

GENERAL NOTES - FLOOR PLANS

- THIS DRAWING IS TO BE READ IN CONJUNCTION WITH ALL GENERAL ARRANGEMENT, PROJECT DETAILS, SPECIFICATIONS AND CONSULTANTS DRAWINGS.
- UNLESS NOTED OTHERWISE, ALL DIMENSIONS ARE TO STRUCTURAL FACES AND/OR PARTITION STUDS.
- ABBREVIATIONS:
MJ MOVEMENT JOINT
HL AT HIGH LEVEL
AAV AIR ADMITTANCE VALVE
SVP SOIL AND VENT PIPE
DP DRAINAGE POINT
RWP RAIN WATER PIPE
J JOISTS
T TRUSSES
SB STRUCTURAL BEAM
- LEGEND
EXTERNAL WALLS:
EXISTING WALL
FACING BRICKWORK
BLOCKWORK, BLOCK STRENGTH TO BE IN ACCORDANCE WITH THE STRUCTURAL ENGINEER'S DETAILS
NON-LOADBEARING PARTITION:
50X75MM CLS TIMBER STUDS AT MAX. 450MM CENTRES WITH 12.5MM B.G. GYPROC WALL BOARD TO EACH SIDE. ALL INTERNAL WALLS TO BE FILLED WITH 75MM ROCKWOOL INSULATION TO ACHIEVE MIN. 40DB SOUND REDUCTION
15MM PLYWOOD PATTERESSING AND MOISTURE RESISTANT BOARD TO BE USED IN ALL BATHROOMS, KITCHENS AND EN-SUITE WET AREAS (GREEN BOARDS)
DENOTES SPAN OF FLOOR JOISTS OVER
PADSTONE (REFER TO S.E. INFORMATION FOR SPECIFICATION)
- FOR ALL STRUCTURAL STEELWORK, PADSTONES, AND MOVEMENT JOINT DETAILS REFER TO THE STRUCTURAL ENGINEER'S DRAWINGS AND DETAILS.
- ALL DRAINAGE RUNS TO BE ABOVE FLOOR UNLESS STATED OTHERWISE.
- ALL KITCHEN LAYOUTS TO SPECIALIST'S DESIGN AND DETAILS
- ALL EXTRACT DUCTS TO BE WITHIN THE FLOOR / ROOF SPACE UNLESS NOTED OTHERWISE.
- AIRFLOW AIRFLOW QT120T VENTILATION EXTRACT
- SMOKE ALARM - TO BE SELF CONTAINED, MAINS FED & INTERCONNECTED, TO COMPLY WITH B.S. 5446 PART 1.
- HEAT DETECTOR A100 EI 144 WITH BATTERY BACK UP
- ALL ELEMENTS OF WORK TO BE INSTALLED ACCORDING TO THE APPROPRIATE MANUFACTURER'S INSTRUCTIONS.

BUILDING CONTROL

Project
NORTH COTTAGE, READING ROAD,
GORING RG8 0LL

PROPOSED FIRST FLOOR PLAN OPTION 1

Date Scale Drawn by Check by
JUNE 22 1:50 @ A1 CA KB
Project No. Drawing No. Revision
22.134 GA.1311 -

Fineline
Architects

T. 07825 615 255


E. info@finelinearchitects.co.uk

W. www.finelinearchitects.co.uk

ROOFLIGHT SCHEDULE				
	OPENING SIZE	ROOM NAME	EXISTING OPENING	NOTES
R1	780 X 1180	GUEST BEDROOM 02 ENSUITE	NO	VELUX CENTRE PIVOT MANUAL OPERATED MK 06 ROOFLIGHT. CLIENTS TO CONFIRM IF OBSCURE GLAZED OR BLINDS TO BE INCLUDED.
R2	780 X 1180	GUEST BEDROOM 01 ENSUITE	NO	VELUX CENTRE PIVOT MANUAL OPERATED MK 06 ROOFLIGHT. CLIENTS TO CONFIRM IF OBSCURE GLAZED OR BLINDS TO BE INCLUDED.
NOT ES	REFERENCES FOR OPENINGS:- D= INTERNAL DOOR, FD= FIRE DOOR FOR 20 MIN. ALLOW 10MM AIR GAP UNDER DOORS TO ALL ROOMS EXCEPT STORE AREAS STRUCTURAL OPENING SIZES BASED ON LEAF SIZE + 42X2 DOOR FRAME. STRUCTURAL OPENINGS WILL VARY FOR ANY OTHER DOOR FRAME SIZE. DOOR HEIGHTS ASSUME CARPET FINISH. ALTERNATIVE FINISHES MAY AFFECT DOOR SETTING OUT.			

Copyright Fineline Architects Ltd. This drawing, or any of its contents, may not be copied, reproduced or distributed without the written consent of Fineline Architects. Do not scale off this drawing. Figured dimensions to be taken from this drawing only. All contractors, subcontractors and/or specialists are responsible for taking and checking all dimensions relating to their work on site. This drawing is to be read in conjunction with all consultants information.

Revision	Issue Date	Dm	Chk
----------	------------	----	-----

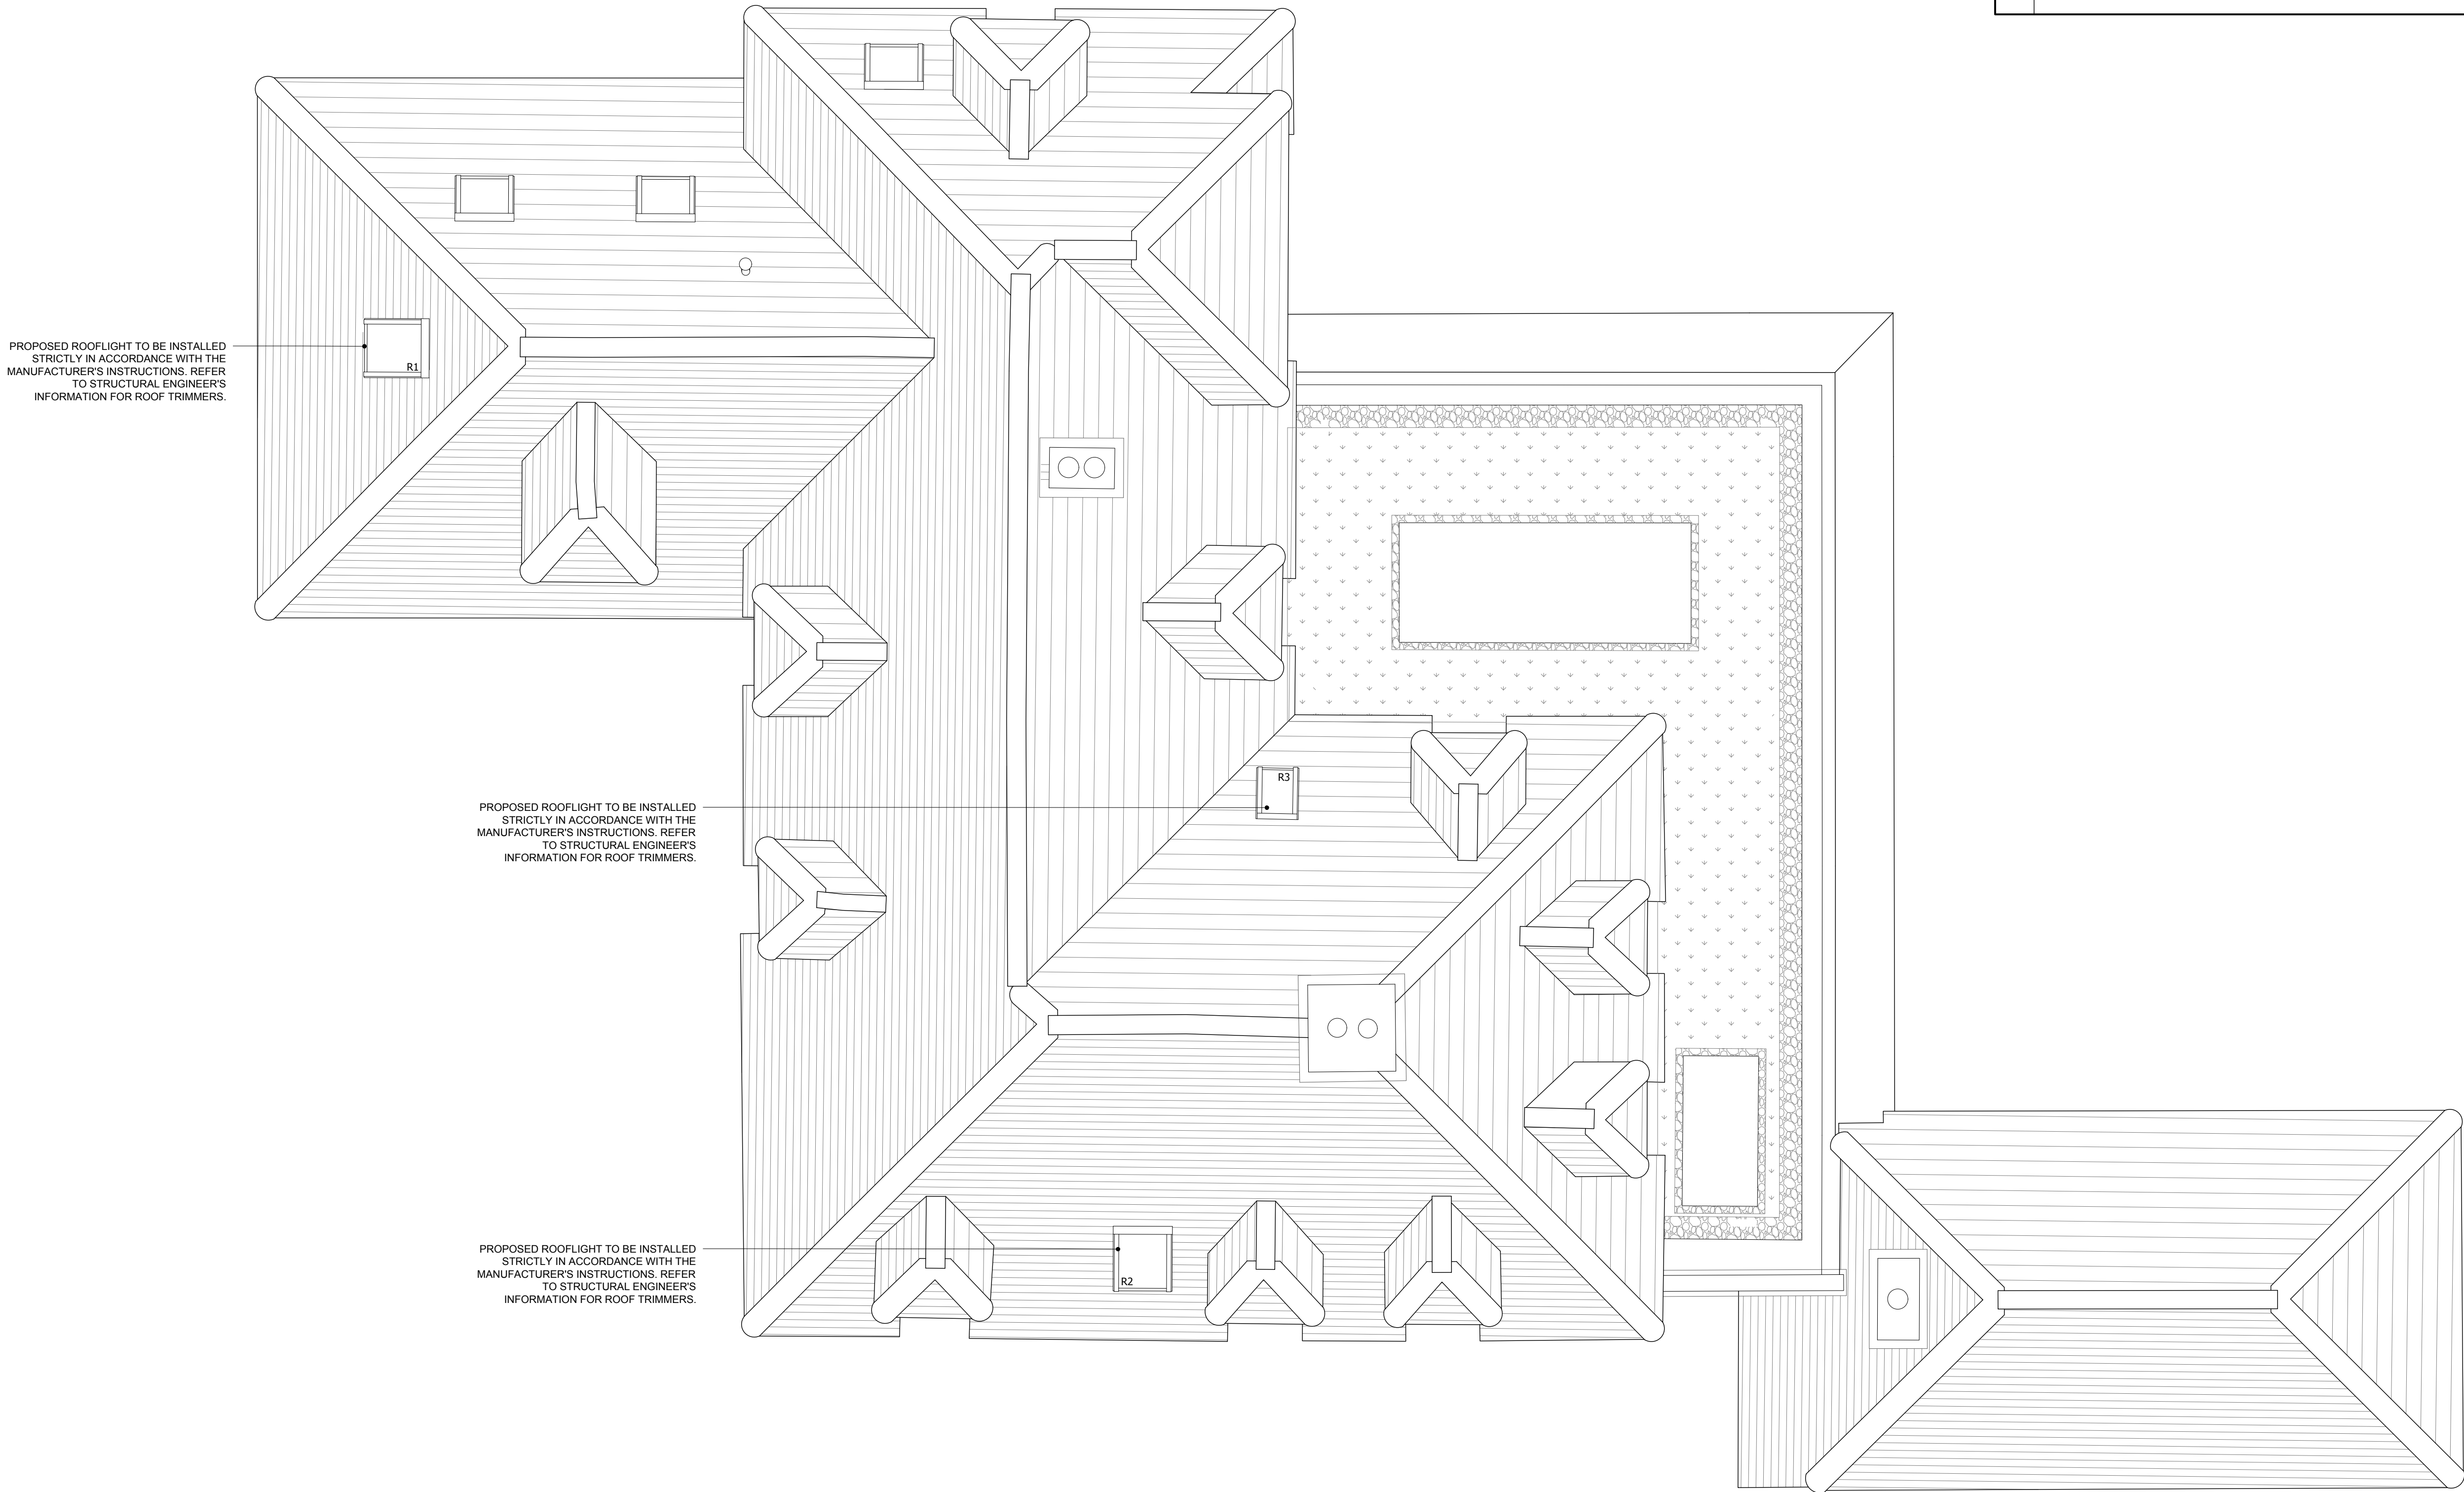

PROPOSED ROOF PLAN

GENERAL NOTES - ROOF

- THIS DRAWING IS TO BE READ IN CONJUNCTION WITH ALL GENERAL ARRANGEMENT, PROJECT DETAILS, SPECIFICATIONS AND CONSULTANTS DRAWINGS.
- UNLESS NOTED OTHERWISE, ALL DIMENSIONS ARE TO STRUCTURAL FACES AND/OR PARTITION STUDS.
- ABBREVIATIONS:
RWP RAINWATER PIPE
RWO RAINWATER OUTLET
- *** ALL GUTTERS TO BE DEEP-FLOW, 115MM WIDE WITH ROUND EDGED OUTLETS. SUPPLIER TO CONFIRM SIZE AND LOCATION OF RWPS.
- SIZES OF EXTRACTS TO BE AS MANUFACTURERS RECOMMENDATIONS. COLOURS TO MATCH ROOF TILES.
- EAVES DIMENSION SHOWN MEASURED FROM BRICK/BLOCK FACE TO EXTERNAL FACE OF FASCIA.
- VERGE DIMENSION SHOWN MEASURED FROM BRICK/BLOCK FACE TO EXTERNAL FACE OF BARGE BOARD.
- ALL ELEMENTS OF WORK TO BE INSTALLED ACCORDING TO THE APPROPRIATE MANUFACTURER'S INSTRUCTIONS.

BUILDING CONTROL


Project
NORTH COTTAGE, READING ROAD,
GORING RG8 0LL

Drawing Title
PROPOSED ROOF PLAN

Date	Scale	Drawn by	Check by
JUNE 22	1:50 @ A1	CA	KB
Project No.	Drawing No.	Revision	
22.134	GA.1312	-	

Fineline
Architects

T. 07825 615 255
E. info@finelinearchitects.co.uk
W. www.finelinearchitects.co.uk

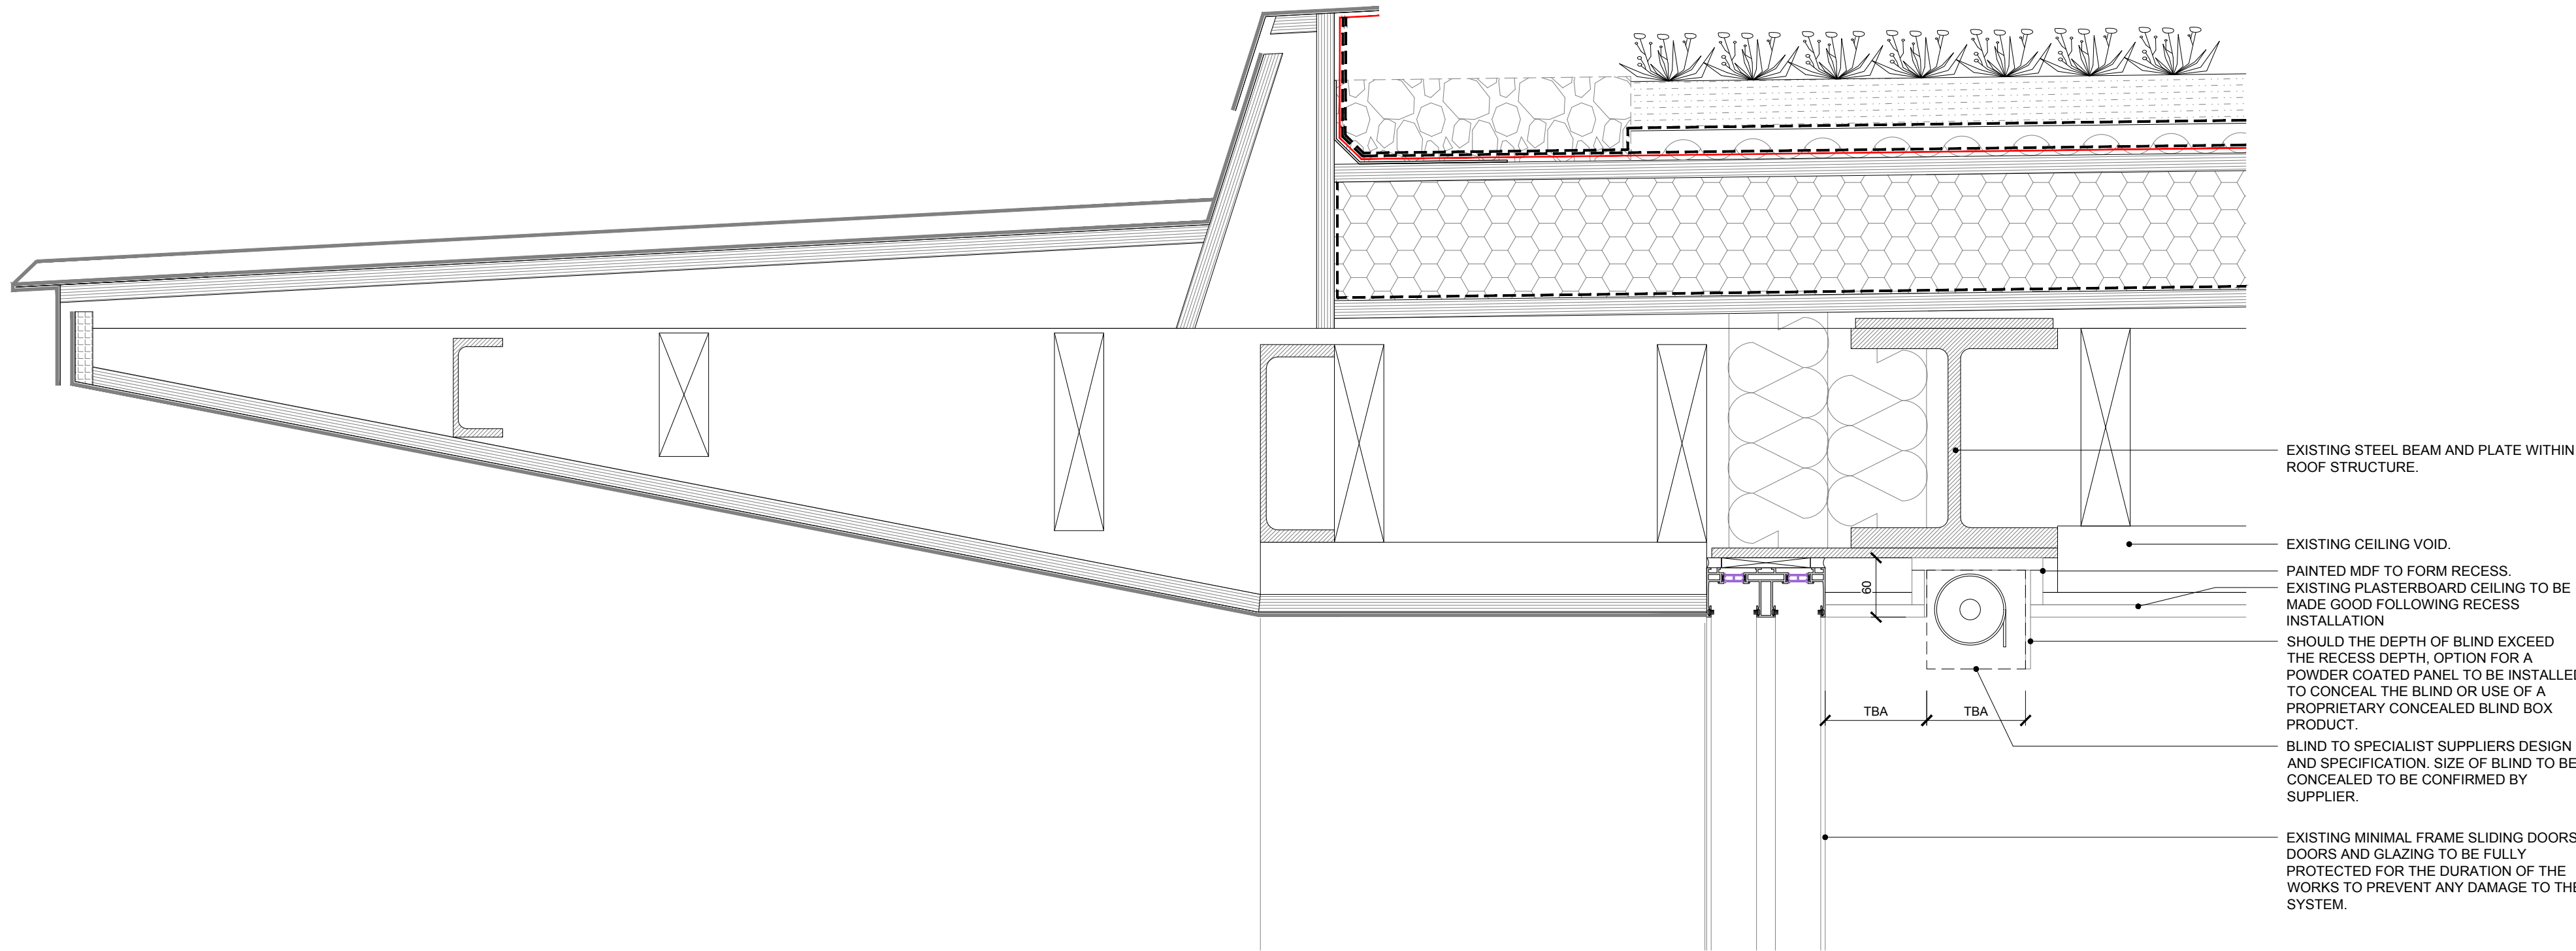

Revision	Issue Date	Dm	Chk

GENERAL NOTES - SECTIONS

- THIS DRAWING IS TO BE READ IN CONJUNCTION WITH ALL GENERAL ARRANGEMENT, PROJECT DETAILS, SPECIFICATIONS AND CONSULTANTS DRAWINGS.
- UNLESS NOTED OTHERWISE, ALL DIMENSIONS ARE TO STRUCTURAL FACES AND/OR PARTITION STUDS.
- ABBREVIATIONS;

ED	EXTERNAL DOOR
W	WINDOW
D	INTERNAL DOORS
FFL	FINISHED FLOOR LEVEL
FCL	FINISHED CEILING LEVEL
- UNLESS NOTED OTHERWISE, ALL VERTICAL DIMENSIONS ARE MEASURED FROM DPC.

2100

INDICATES THE VERTICAL DISTANCE ABOVE FFL
- EAVES DIMENSION SHOWN MEASURED FROM BRICK/BLOCK FACE TO EXTERNAL FACE OF FASCIA
- GROUND LEVEL IS SHOWN APPROXIMATE ONLY
- ALL ELEMENTS OF WORK TO BE INSTALLED ACCORDING TO THE APPROPRIATE MANUFACTURER'S INSTRUCTIONS.

STATUS

BUILDING CONTROL

Project
NORTH COTTAGE, READING ROAD,
GORING RG8 0LL

Drawing Title
PROPOSED SECTION A-A

Date	Scale	Drawn by	Check by
JUNE 22	1:5 @ A1	CA	KB
Project No.	Drawing No.	Revision	
22.134	GA.1410	-	

Fineline
Architects

Revision	Issue Date	Dm	Chk



EXISTING STREET ELEVATION



EXISTING SIDE ELEVATION

GENERAL NOTES - DEMOLITION

- THIS DRAWING IS TO BE READ IN CONJUNCTION WITH ALL GENERAL ARRANGEMENT, PROJECT DETAILS, SPECIFICATIONS AND CONSULTANTS DRAWINGS.
- UNLESS NOTED OTHERWISE, ALL DIMENSIONS ARE TO STRUCTURAL FACES AND/OR PARTITION STUDS.
- LEGEND

DEMOLITION WORKS

Status
BUILDING CONTROL

Project
NORTH COTTAGE, READING ROAD,
GORING RG8 0LL
Drawing Title
EXISTING ELEVATIONS
SHEET 1

Date	Scale	Drawn by	Check by
JUNE 22	1:50 @ A1	CA	KB
Project No.	Drawing No.	Revision	
22.134	GA.1500	-	

Fineline
Architects

T. 07825 615 255
E. info@finelinearchitects.co.uk
W. www.finelinearchitects.co.uk

Revision	Issue Date	Dm	Chk



EXISTING REAR ELEVATION



EXISTING SIDE ELEVATION

GENERAL NOTES - DEMOLITION

- THIS DRAWING IS TO BE READ IN CONJUNCTION WITH ALL GENERAL ARRANGEMENT, PROJECT DETAILS, SPECIFICATIONS AND CONSULTANTS DRAWINGS.
- UNLESS NOTED OTHERWISE, ALL DIMENSIONS ARE TO STRUCTURAL FACES AND/OR PARTITION STUDS.
- LEGEND

DEMOLITION WORKS

Status
BUILDING CONTROL

Project
NORTH COTTAGE, READING ROAD,
GORING RG8 0LL
Drawing Title
EXISTING ELEVATIONS
SHEET 2

Date	Scale	Drawn by	Check by
JUNE 22	1:50 @ A1	CA	KB
Project No.	Drawing No.	Revision	
22.134	GA.1501	-	

Fineline
Architects

T. 07825 615 255
E. info@finelinearchitects.co.uk
W. www.finelinearchitects.co.uk

Revision	Issue Date	Dm	Chk



PROPOSED STREET ELEVATION



PROPOSED SIDE ELEVATION

GENERAL NOTES - ELEVATIONS

- THIS DRAWING IS TO BE READ IN CONJUNCTION WITH ALL GENERAL ARRANGEMENT, PROJECT DETAILS, SPECIFICATIONS AND CONSULTANTS DRAWINGS.
- UNLESS NOTED OTHERWISE, ALL DIMENSIONS ARE TO STRUCTURAL FACES AND/OR PARTITION STUDS.
- ABBREVIATIONS:

ED	EXTERNAL DOOR
W	WINDOW
#	EMERGENCY ESCAPE WINDOW TO COMPLY WITH AD PART B1
SG	SAFETY GLASS
OG	OBSCURE GLAZING
MJ	MOVEMENT JOINT
FFL	FINISHED FLOOR LEVEL
FCL	FINISHED CEILING LEVEL
RWP	RAINWATER PIPE
- LEGEND:

	OBSCURE GLAZING
--	-----------------
- UNLESS NOTED OTHERWISE, ALL VERTICAL DIMENSIONS ARE MEASURED FROM DPC.
- EAVES DIMENSION SHOWN MEASURED FROM BRICK/BLOCK FACE TO EXTERNAL FACE OF FASCIA.
- MINIMUM DISTANCE BETWEEN EXTRACTS AND OPENINGS TO BE 300MM. SIZES OF EXTRACTS AND FLUES TO BE AS MANUFACTURER'S RECOMMENDATIONS. COLOURS TO MATCH SURROUNDING MATERIAL AS APPROPRIATE.
- GROUND LEVEL IS SHOWN APPROXIMATE ONLY.
- FOR ALL MOVEMENT JOINT LOCATIONS REFER TO STRUCTURAL ENGINEERS DRAWINGS - COLOUR OF MOVEMENT JOINT SEALANT TO MATCH FACING BRICK.
- RENDERED ELEVATIONS TO HAVE BED JOINT REINFORCEMENT AT 450MM HORIZONTAL CENTRES. ADDITIONAL REINFORCEMENT AS REQUIRED DIRECTLY ABOVE AND BELOW DOOR / WINDOW OPENINGS EXTENDING 600MM EITHER SIDE. REFER TO STRUCTURAL ENGINEERS DETAILS FOR ALL BED JOINT REINFORCEMENT AND MOVEMENT JOINT LOCATIONS.
- ALL ELEMENTS OF WORK TO BE INSTALLED ACCORDING TO THE APPROPRIATE MANUFACTURER'S INSTRUCTIONS.

Building Control

Project
NORTH COTTAGE, READING ROAD,
GORING RG8 0LL

Proposed Elevations

Sheet 1

Date	Scale	Drawn by	Check by
JUNE 22	1:50 @ A1	CA	KB
Project No.	Drawing No.	Revision	
22.134	GA.1510	-	

Fineline
Architects

T. 07825 615 255
E. info@finelinearchitects.co.uk
W. www.finelinearchitects.co.uk

Revision	Issue Date	Dm	Chk



PROPOSED REAR ELEVATION



PROPOSED SIDE ELEVATION

GENERAL NOTES - ELEVATIONS

- THIS DRAWING IS TO BE READ IN CONJUNCTION WITH ALL GENERAL ARRANGEMENT, PROJECT DETAILS, SPECIFICATIONS AND CONSULTANTS DRAWINGS.
- UNLESS NOTED OTHERWISE, ALL DIMENSIONS ARE TO STRUCTURAL FACES AND/OR PARTITION STUDS.
- ABBREVIATIONS:

ED	EXTERNAL DOOR
W	WINDOW
#	EMERGENCY ESCAPE WINDOW TO COMPLY WITH AD PART B1
SG	SAFETY GLASS
OG	OBSCURE GLAZING
MJ	MOVEMENT JOINT
FFL	FINISHED FLOOR LEVEL
FCL	FINISHED CEILING LEVEL
RWP	RAINWATER PIPE
- LEGEND:

	OBSCURE GLAZING
--	-----------------
- UNLESS NOTED OTHERWISE, ALL VERTICAL DIMENSIONS ARE MEASURED FROM DPC.
- INDICATES THE VERTICAL DISTANCE ABOVE DPC/FFL
- EAVES DIMENSION SHOWN MEASURED FROM BRICK/BLOCK FACE TO EXTERNAL FACE OF FASCIA.
- MINIMUM DISTANCE BETWEEN EXTRACTS AND OPENINGS TO BE 300MM. SIZES OF EXTRACTS AND FLUES TO BE AS MANUFACTURER'S RECOMMENDATIONS. COLOURS TO MATCH SURROUNDING MATERIAL AS APPROPRIATE.
- GROUND LEVEL IS SHOWN APPROXIMATE ONLY.
- FOR ALL MOVEMENT JOINT LOCATIONS REFER TO STRUCTURAL ENGINEERS DRAWINGS - COLOUR OF MOVEMENT JOINT SEALANT TO MATCH FACING BRICK.
- RENDERED ELEVATIONS TO HAVE BED JOINT REINFORCEMENT AT 450MM HORIZONTAL CENTRES. ADDITIONAL REINFORCEMENT AS REQUIRED DIRECTLY ABOVE AND BELOW DOOR / WINDOW OPENINGS EXTENDING 600MM EITHER SIDE. REFER TO STRUCTURAL ENGINEERS DETAILS FOR ALL BED JOINT REINFORCEMENT AND MOVEMENT JOINT LOCATIONS.
- ALL ELEMENTS OF WORK TO BE INSTALLED ACCORDING TO THE APPROPRIATE MANUFACTURER'S INSTRUCTIONS.

STATUS BUILDING CONTROL

Project
NORTH COTTAGE, READING ROAD,
GORING RG8 0LL


Drawing Title PROPOSED ELEVATIONS SHEET 2

Date	Scale	Drawn by	Check by
JUNE 22	1:50 @ A1	CA	KB
Project No.	Drawing No.	Revision	
22.134	GA.1511	-	

Fineline
Architects

T. 07825 615 255
E. info@finelinearchitects.co.uk
W. www.finelinearchitects.co.uk

Revision	Issue Date	Dm	Chk

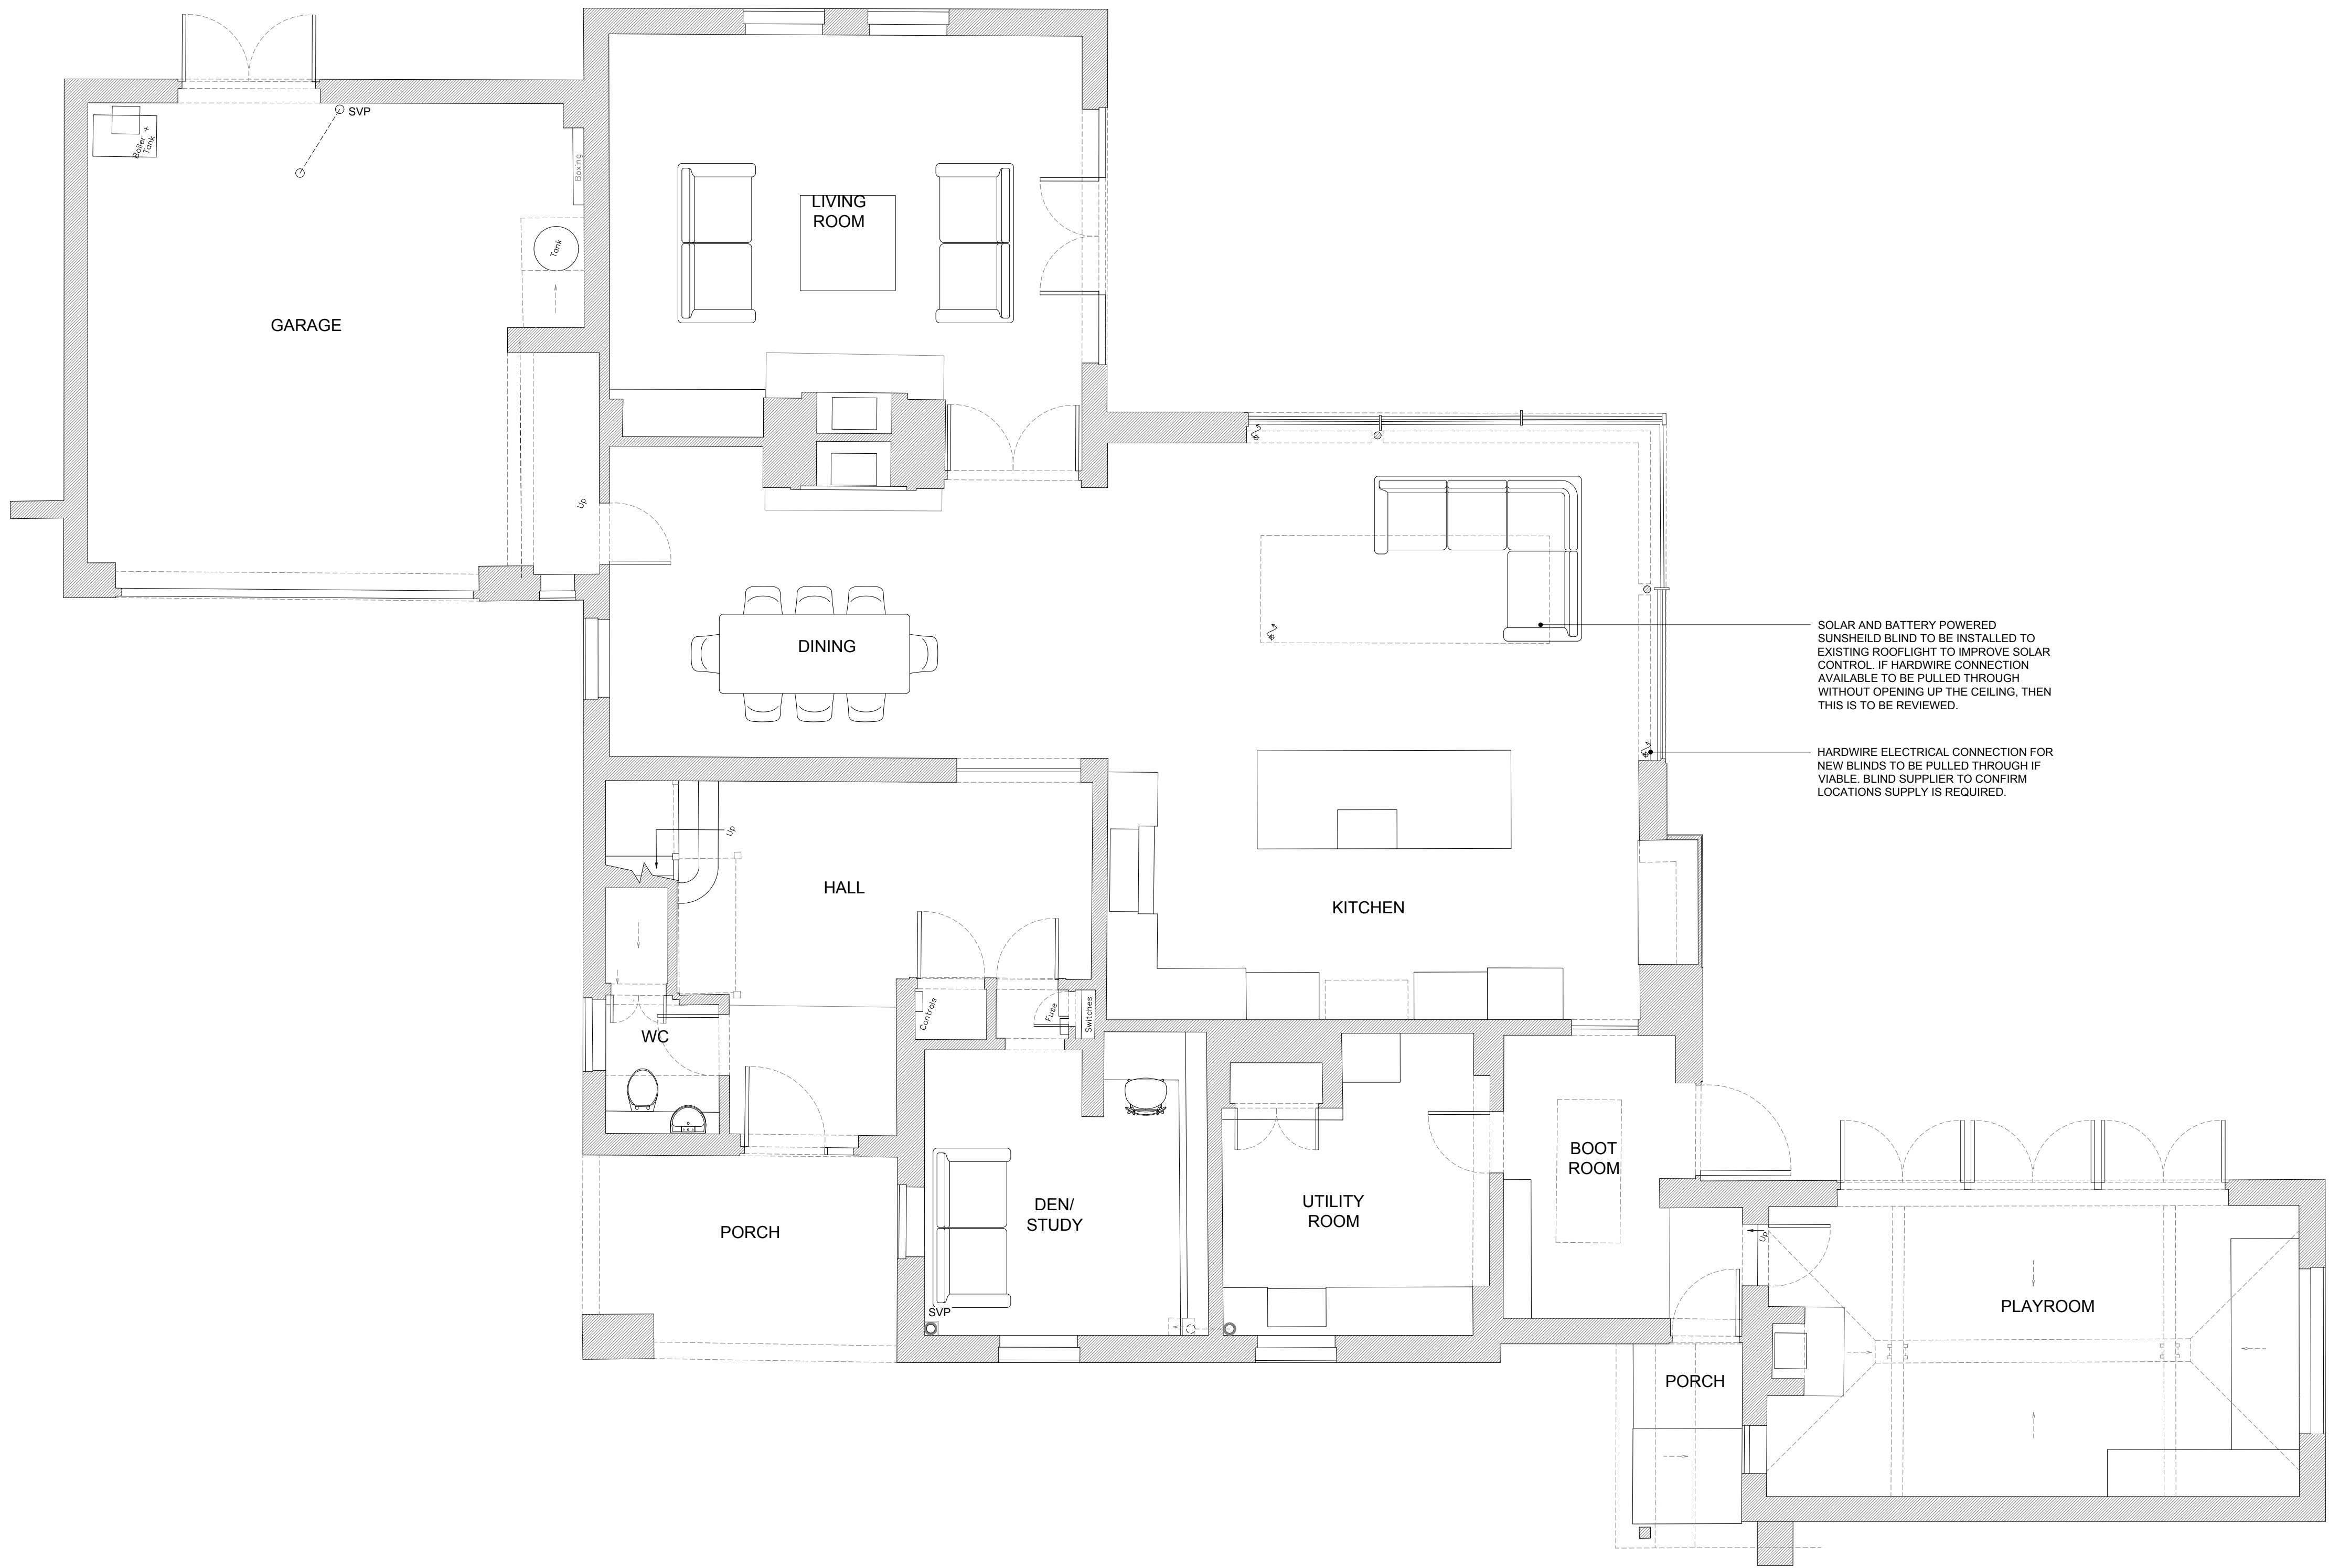

- LIGHT SWITCH
- D DIMMER LIGHT SWITCH
- ⌘ DOWNLIGHT
- ⌘ U UPLIGHT
- (P) PENDANT LIGHT - CLIENT SUPPLY
- ⌘ WALL MOUNTED LIGHT - CLIENT SUPPLY
- LED LINEAR LED
- ⌘ POWER SUPPLY FOR ELECTRIC BLINDS
- C1 PROPOSED LIGHTING CIRCUIT & CIRCUIT NUMBER
- (S) SMOKE DETECTOR & SOUNDER (MAINS OPERATED AND INTER-LINKED).
- (H) HEAT DETECTOR & SOUNDER (MAINS OPERATED AND INTER-LINKED).
- CO CARBON MONOXIDE DETECTOR & SOUNDER (MAINS OPERATED AND INTER-LINKED).
- NOTES
- SWITCHES AND SOCKETS TO BE DETA SLIMLINE WHITE RANGE UNLESS NOTED OTHERWISE
- ALL SWITCHES, SOCKET OUTLETS AND OTHER CONTROLS TO BE INSTALLED BETWEEN 450MM AND 1200MM ABOVE FFL IN ACCORDANCE WITH BUILDING REGULATIONS

PROPOSED GROUND FLOOR PLAN

Status
BUILDING CONTROL


Project
NORTH COTTAGE, READING ROAD,
GORING RG8 0LL

Drawing Title
PROPOSED GROUND FLOOR
REFLECTED CEILING PLAN


Date	Scale	Drawn by	Check by
JUNE 22	1:50 @ A1	CA	KB
Project No.	Drawing No.	Revision	
22.134	GA.1610	-	

Fineline
Architects

T. 07825 615 255
E. info@finelinearchitects.co.uk
W. www.finelinearchitects.co.uk

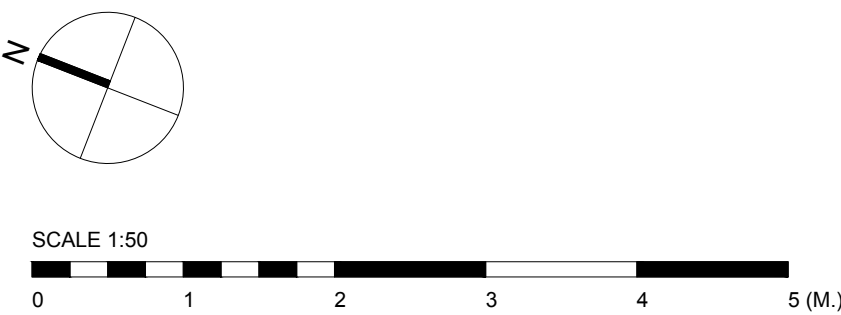

Revision	Issue Date	Dm	Chk

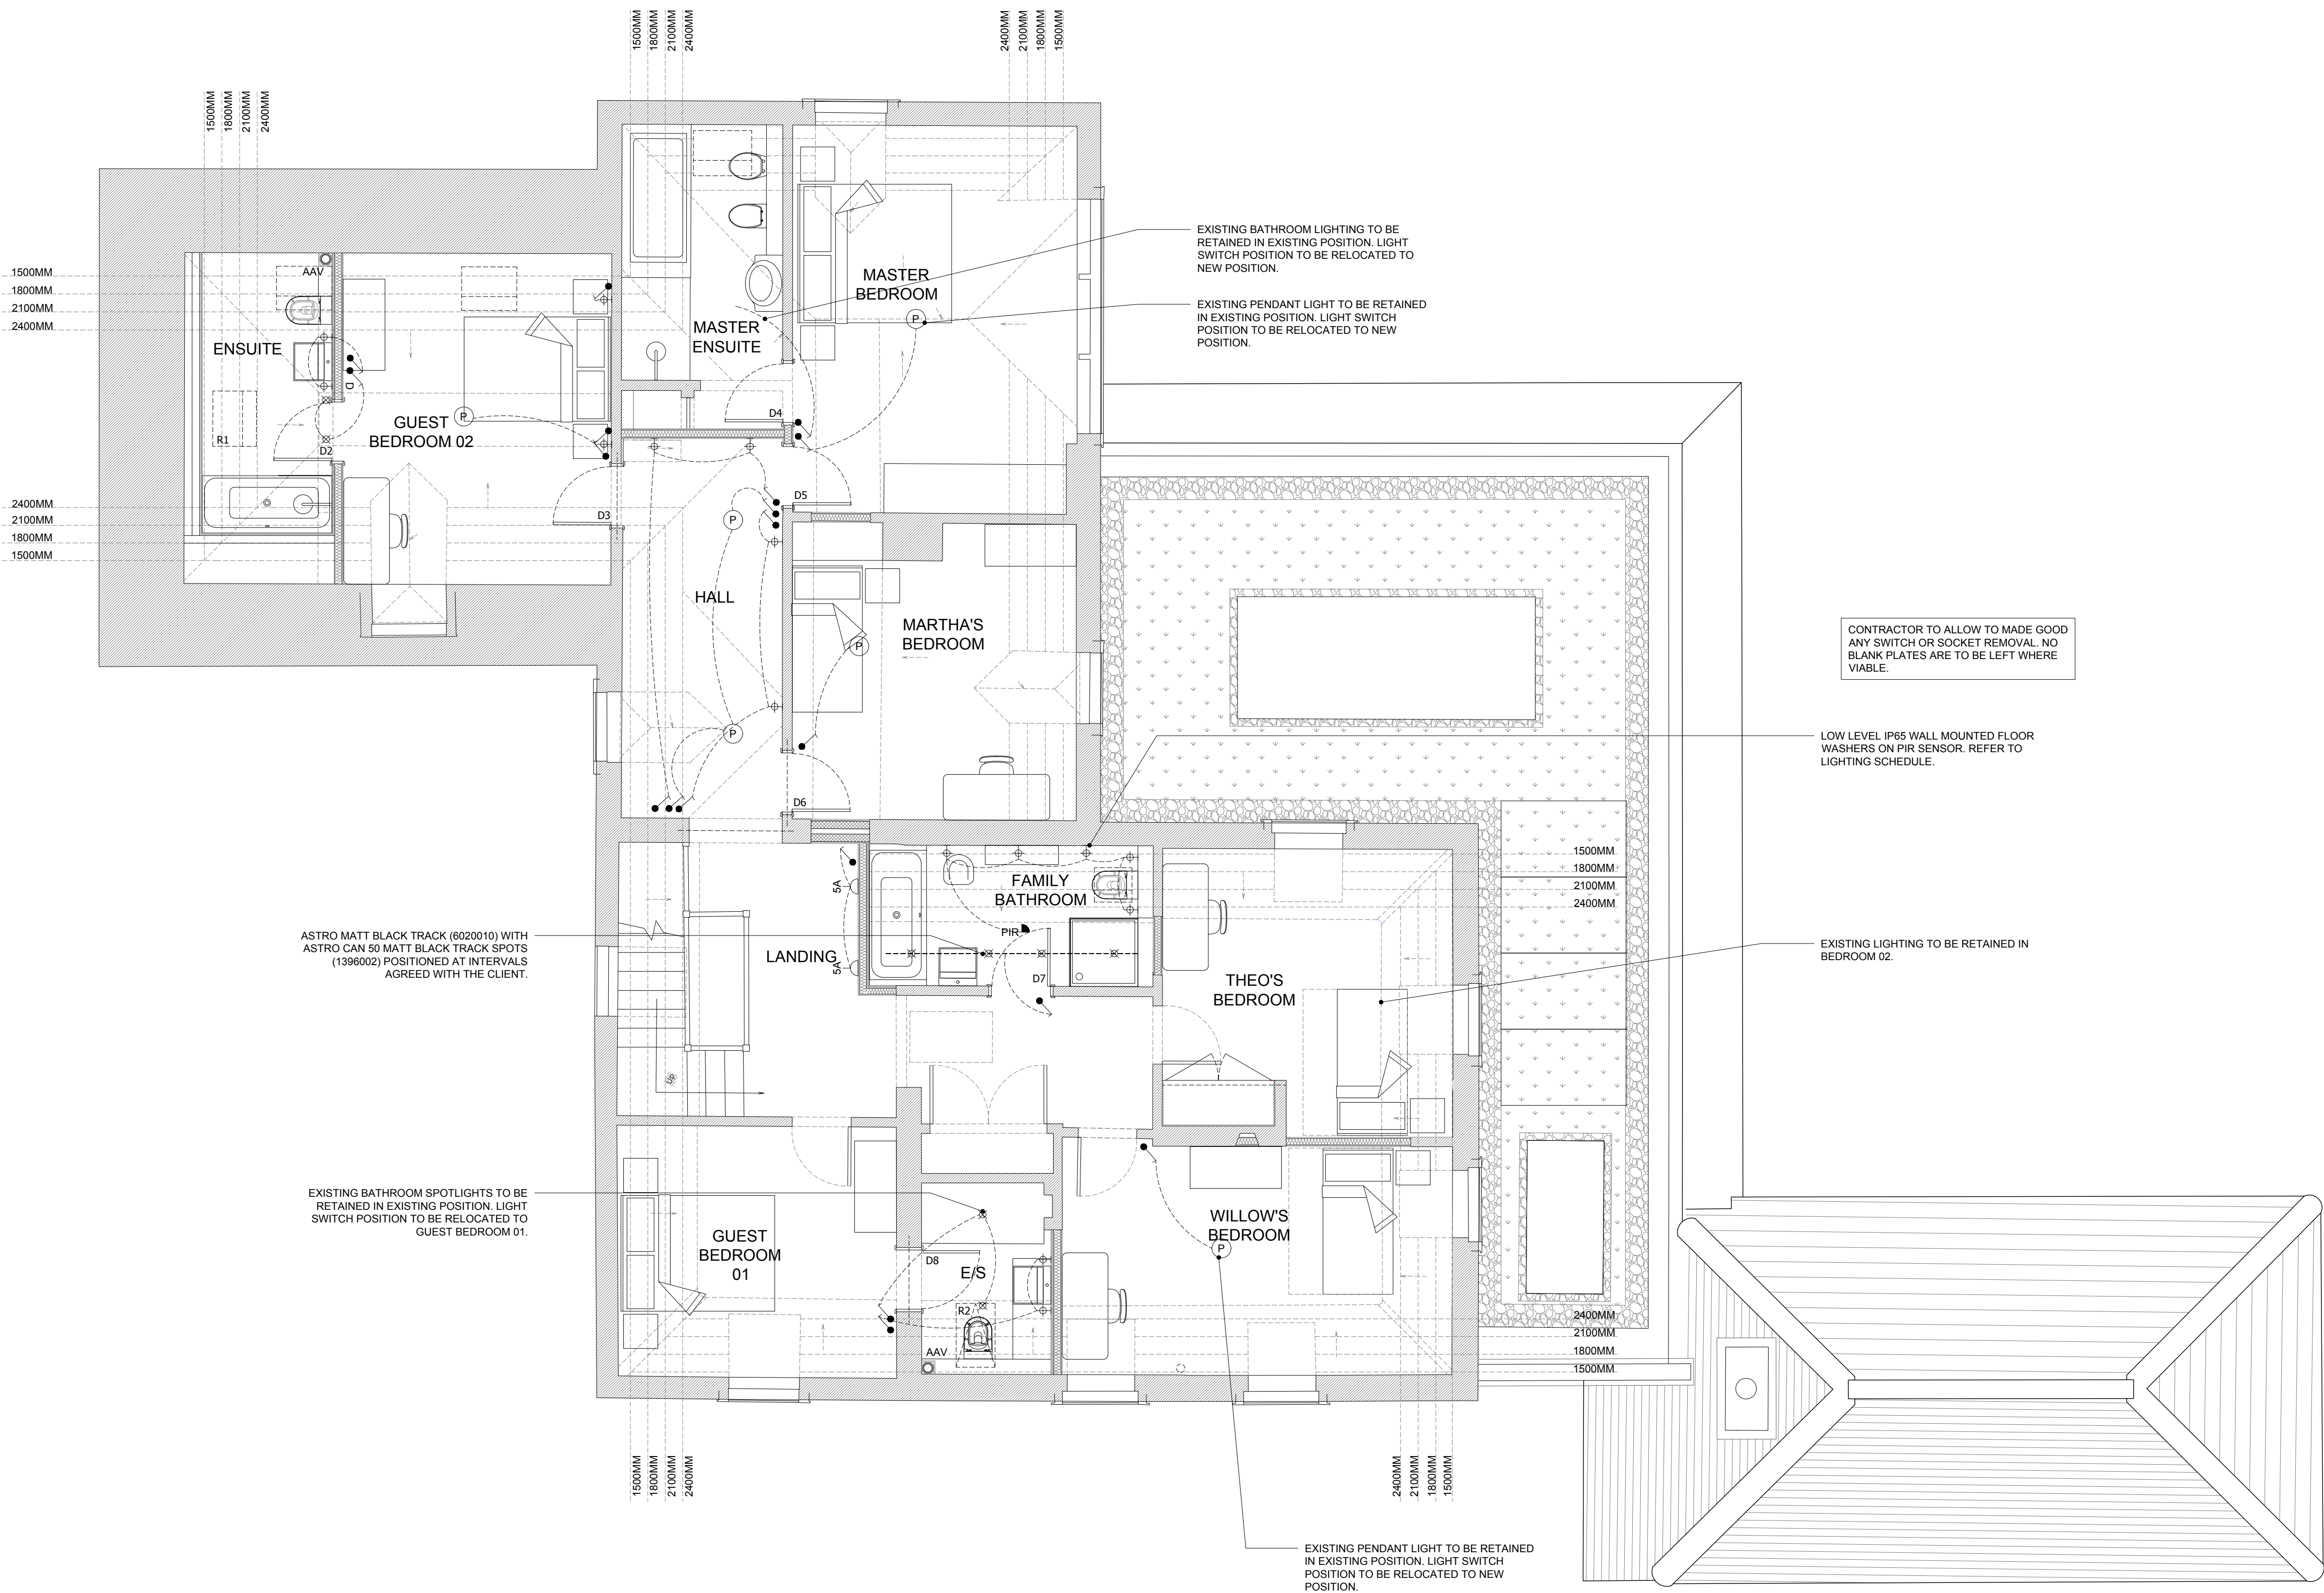


- LIGHT SWITCH
- D DIMMER LIGHT SWITCH
- ⌘ DOWNLIGHT
- ⌘ U UPLIGHT
- (P) PENDANT LIGHT - CLIENT SUPPLY
- ⌘ WALL MOUNTED LIGHT - CLIENT SUPPLY
- LED LINEAR LED
- ⌘ POWER SUPPLY FOR ELECTRIC BLINDS
- C1 PROPOSED LIGHTING CIRCUIT & CIRCUIT NUMBER
- (S) SMOKE DETECTOR & SOUNDER (MAINS OPERATED AND INTER-LINKED).
- (H) HEAT DETECTOR & SOUNDER (MAINS OPERATED AND INTER-LINKED).
- CO CARBON MONOXIDE DETECTOR & SOUNDER (MAINS OPERATED AND INTER-LINKED).
- NOTES
- SWITCHES AND SOCKETS TO BE DETA SLIMLINE WHITE RANGE UNLESS NOTED OTHERWISE
- ALL SWITCHES, SOCKET OUTLETS AND OTHER CONTROLS TO BE INSTALLED BETWEEN 450MM AND 1200MM ABOVE FFL IN ACCORDANCE WITH BUILDING REGULATIONS

BUILDING CONTROL

Project	NORTH COTTAGE, READING ROAD, GORING RG8 0LL		
Drawing Title	PROPOSED FIRST FLOOR REFLECTED CEILING PLAN		
Date	Scale	Drawn by	Check by
JUNE 22	1:50 @ A1	CA	KB
Project No.	Drawing No.	Revision	
22.134	GA.1611	-	

Fineline Architects

T. 07825 615 255
E. info@finelinearchitects.co.uk
W. www.finelinearchitects.co.uk

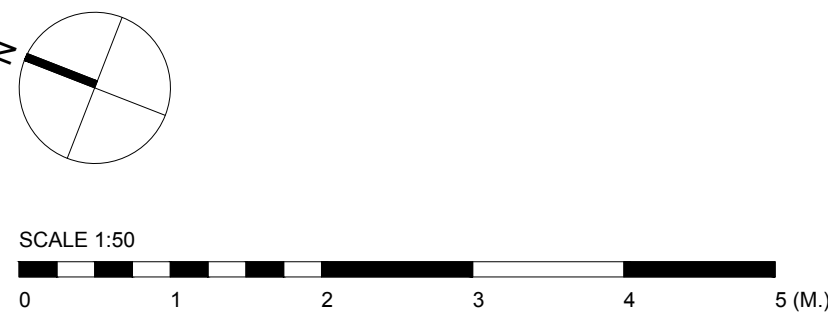

Revision	Issue Date	Dm	Chk

- 

SINGLE 13A SSO
- 

DOUBLE 13A SSO
- 

SINGLE 5A SSO
- 

SINGLE 13A SSO 150MM ABOVE WORKTOP
- 

DOUBLE 13A SSO 150MM ABOVE WORKTOP
- 

SWITCHED FUSED SPUR WIRED TO 13A SOCKET OUTLET OR APPLIANCE
- 

SHAVER SOCKET
- 

COOKER SWITCH
- 

MECHANICAL EXTRACTOR
- 

DISTRIBUTION BOARD WITH MIN. 2 NO. SPARE FUSEWAYS
- 

BOILER
- 

AIR SOURCE HEAT PUMP
- 

BOILER/ASHP PROGRAMMER
- 

MECHANICAL VENTILATION HEAT RECOVERY UNIT
- 

UNVENTED HOT WATER CYLINDER
- 

WATER SOFTNER
- 

UNDERFLOOR HEATING MANIFOLD
- 

THERMOSTAT
- 

RADIATOR
- 

DOOR BELL PUSH BUTTON
- 

DOOR BELL SOUNDER C/W WITH CHIMES & TRANSFORMER
- 

TV AERIAL POINT
- 

BT MASTER SOCKET
- 

CAT 6 DATA OUTLET
- 

TELEPHONE OUTLET
- 

ALARM KEYPAD PANEL
- 

SECURITY ALARM SOUNDER
- 

PIR SENSOR
- 

NOTES
- 

SWITCHES AND SOCKETS TO BE DETA SLIMLINE WHITE RANGE UNLESS NOTED OTHERWISE
- 

ALL SWITCHES, SOCKET OUTLETS AND OTHER CONTROLS TO BE INSTALLED BETWEEN 450MM AND 1200MM ABOVE FFL IN ACCORDANCE WITH BUILDING REGULATIONS



Status

BUILDING CONTROL


Project	NORTH COTTAGE, READING ROAD, GORING RG8 0LL		
Drawing Title	PROPOSED FIRST FLOOR ELECTRICAL PLAN		
Date	Scale	Drawn by	Check by
JUNE 22	1:50 @ A1	CA	KB
Project No.	Drawing No.	Revision	
22.134	GA.1710	-	

Fineline
Architects


T. 07825 615 255
E. info@finelinearchitects.co.uk
W. www.finelinearchitects.co.uk

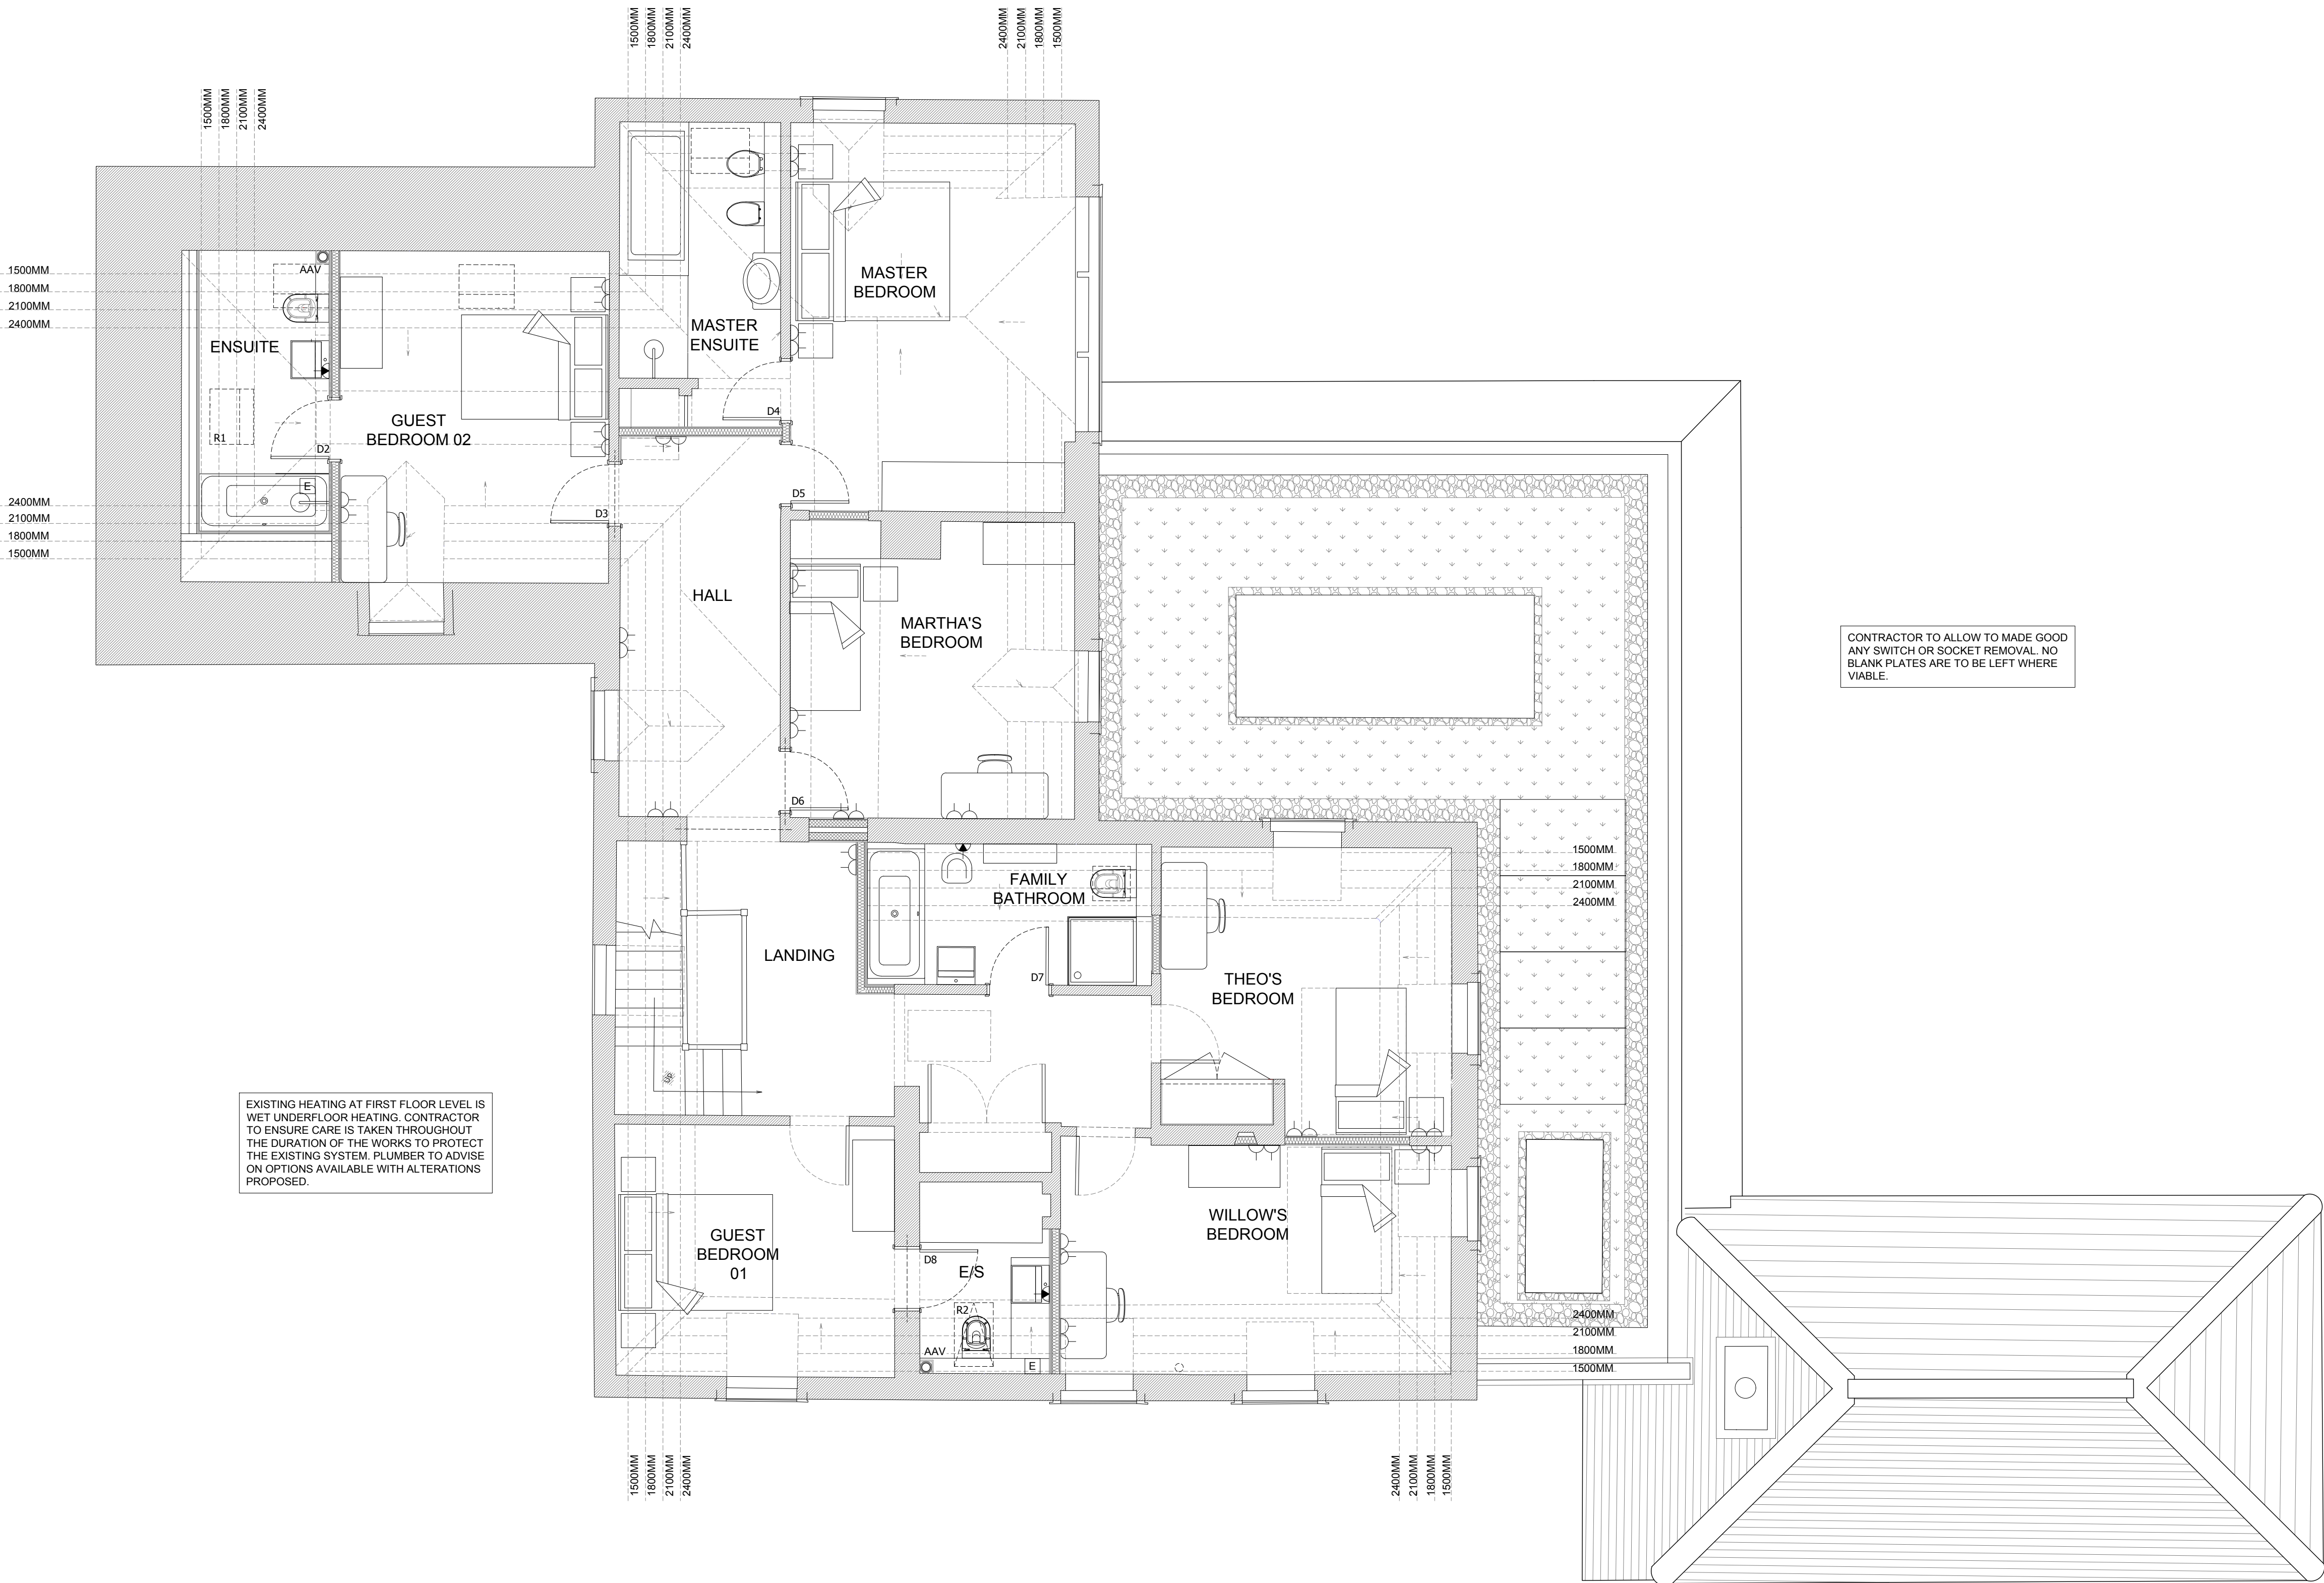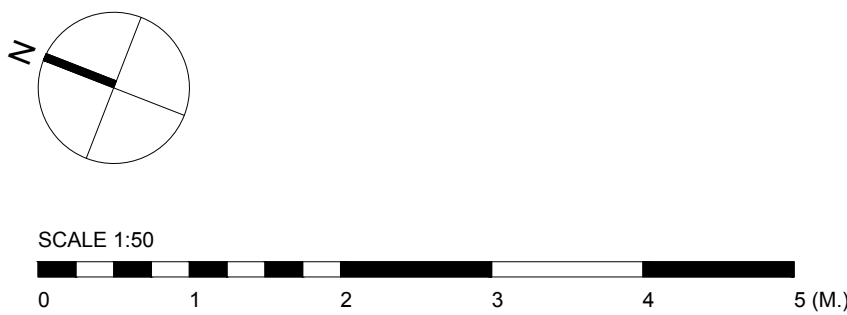


Revision	Issue Date	Dm	Chk

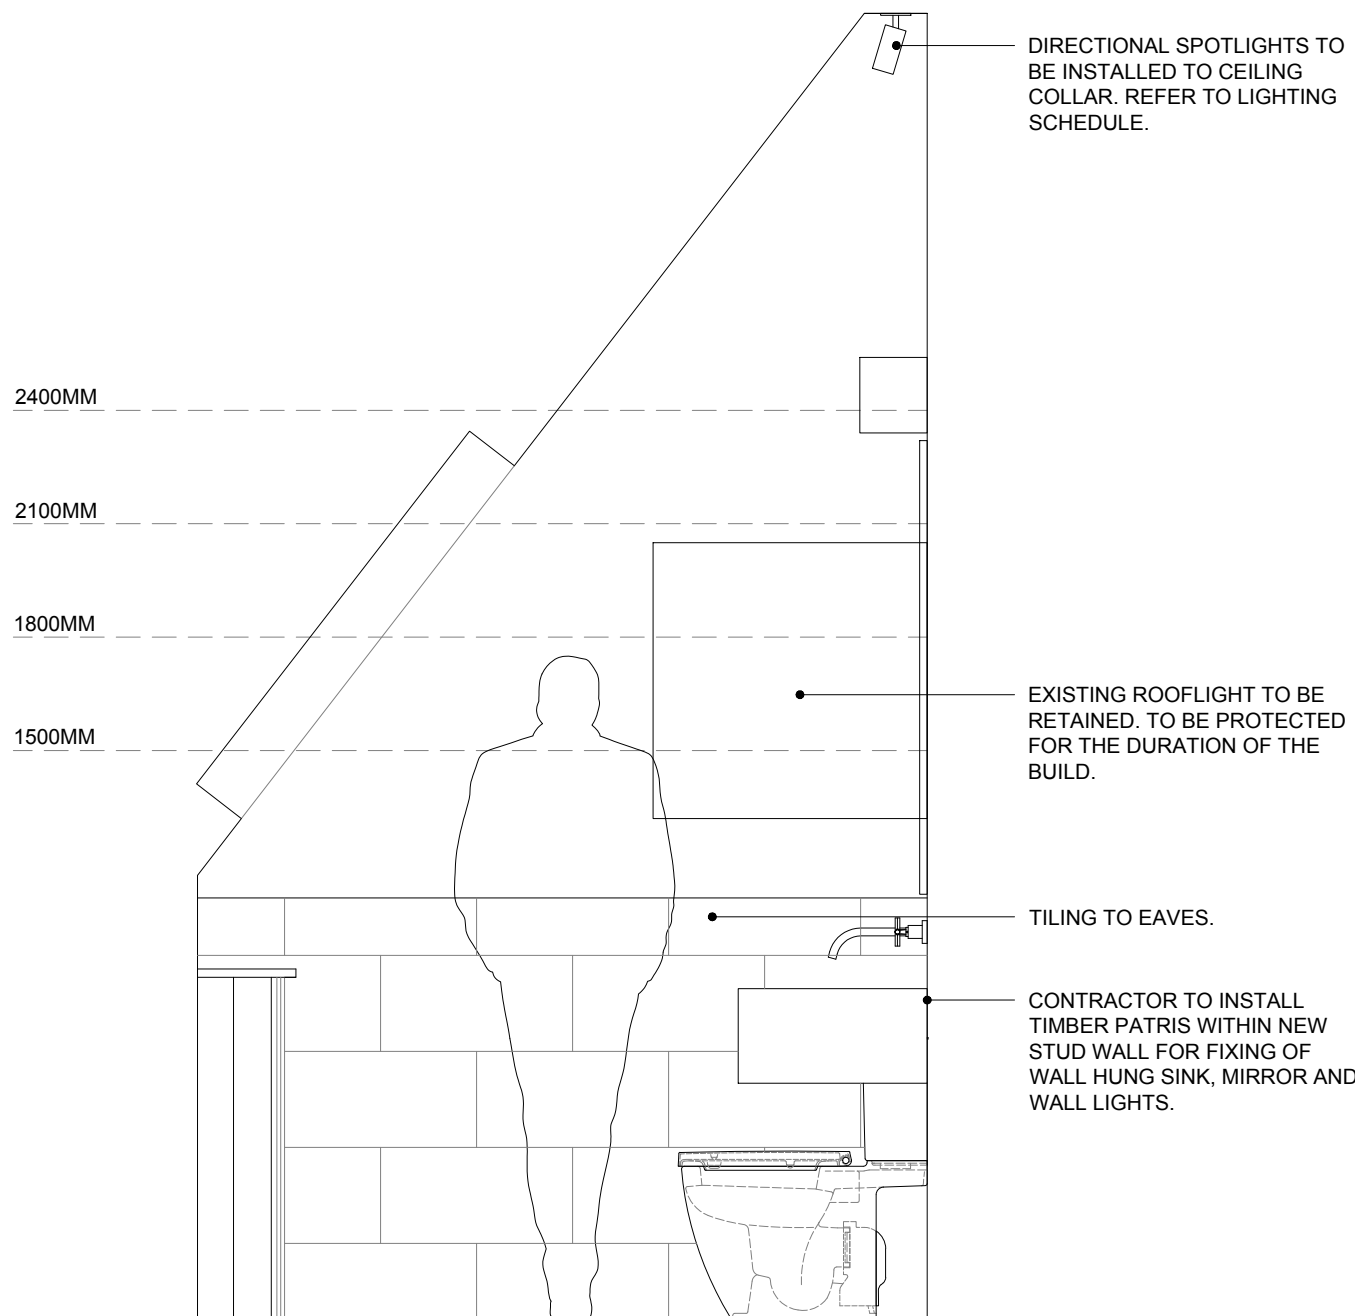



ELEVATION A

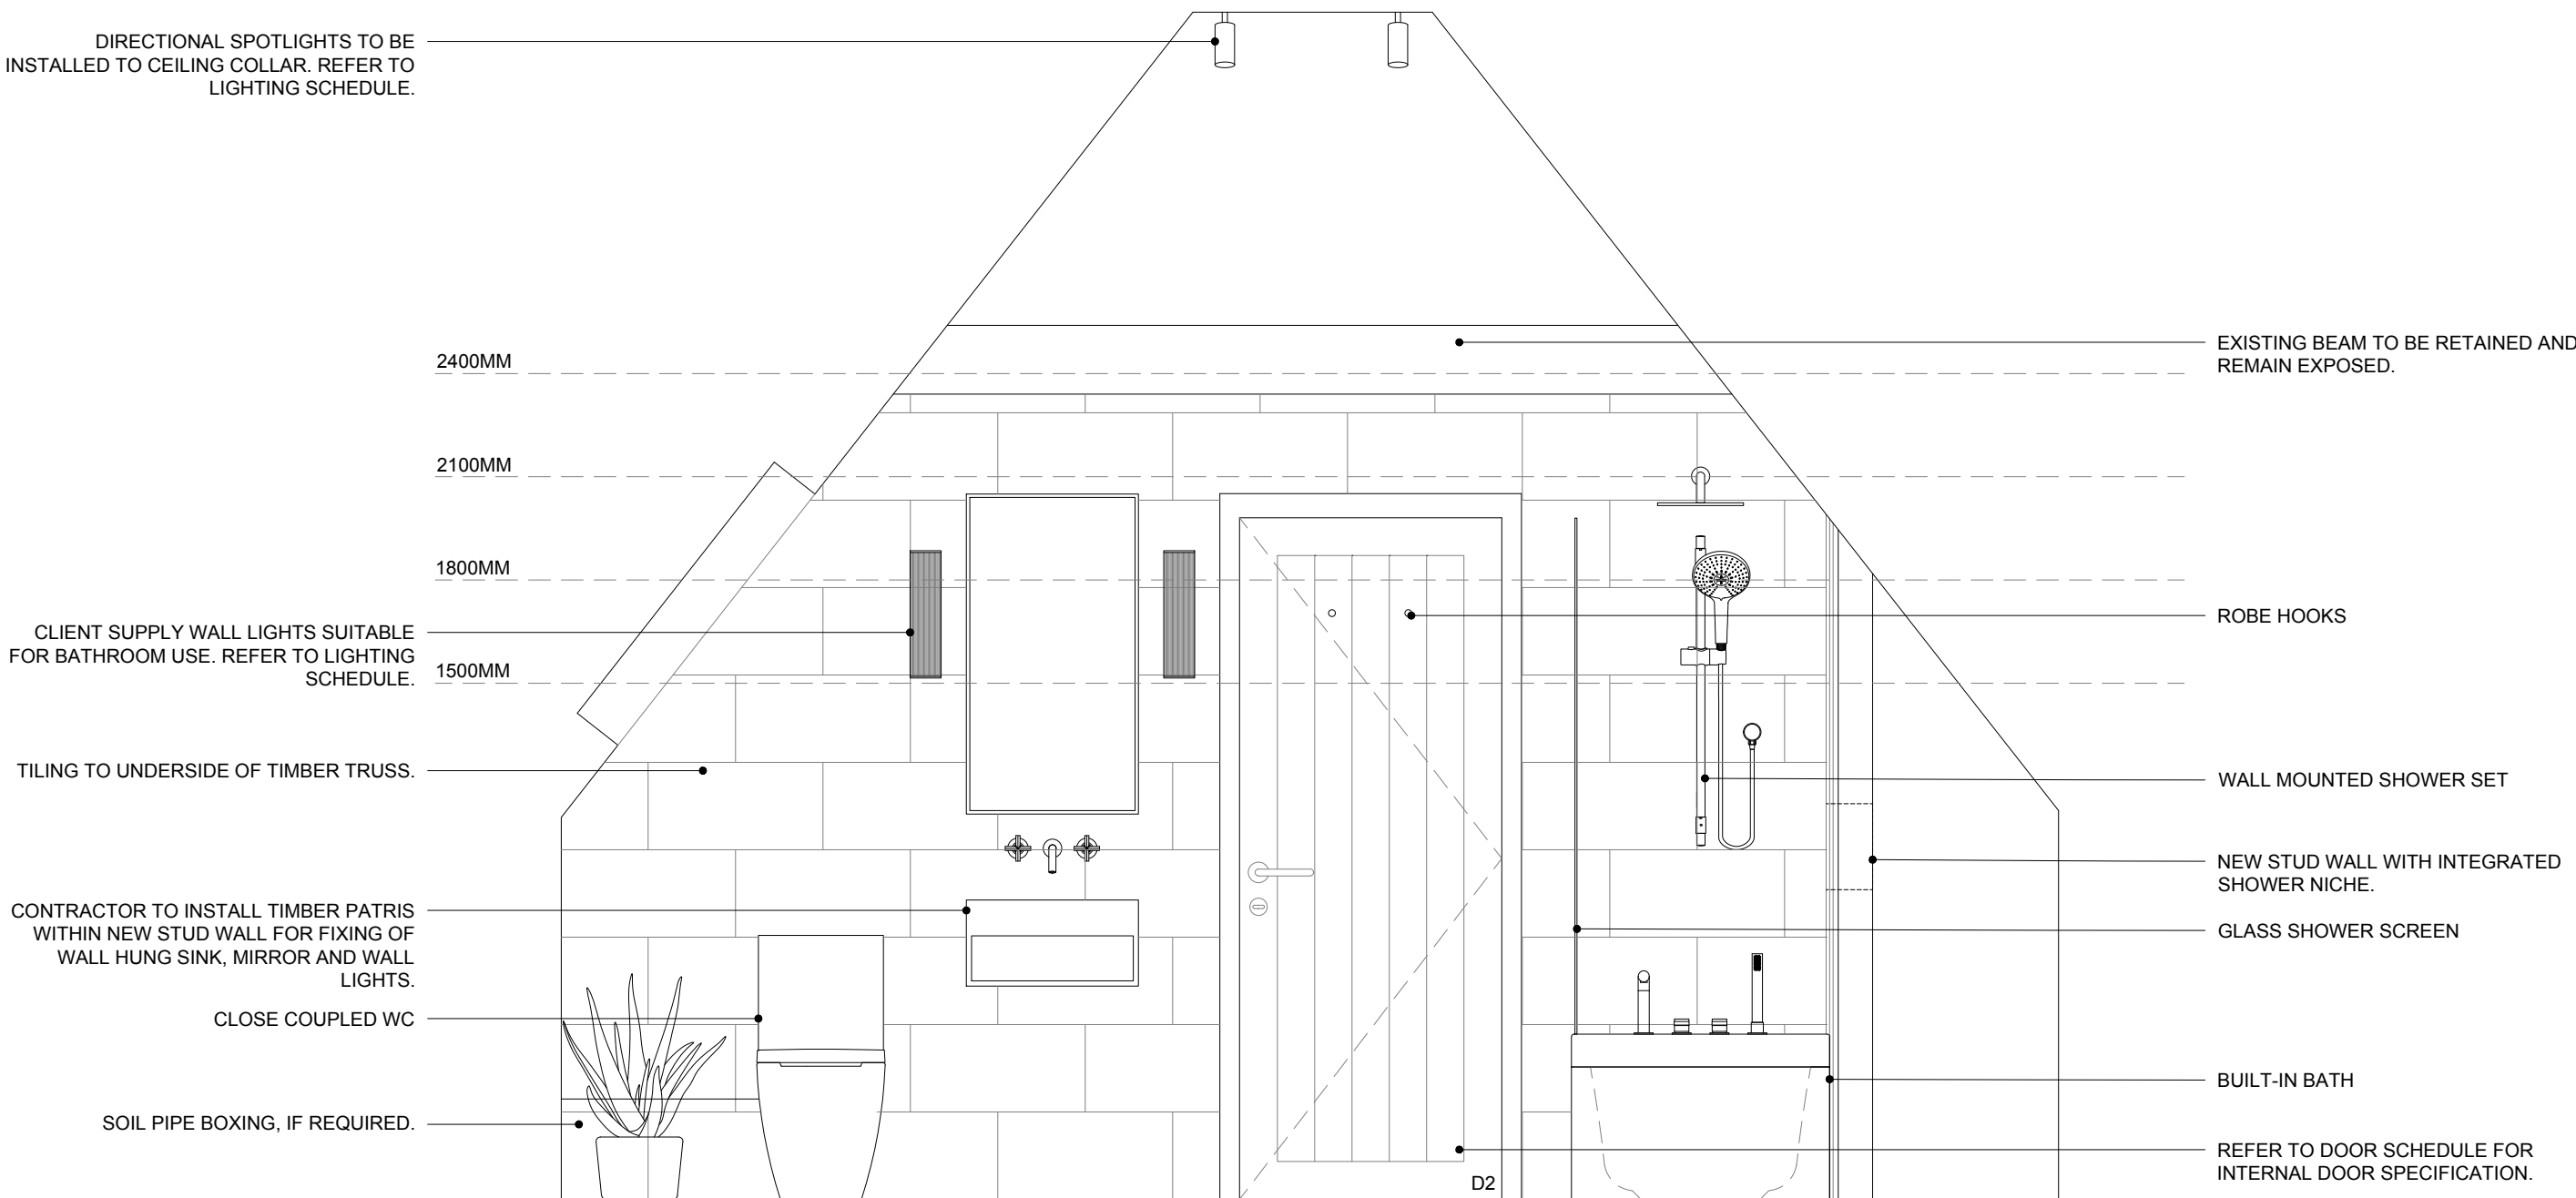


ELEVATION B

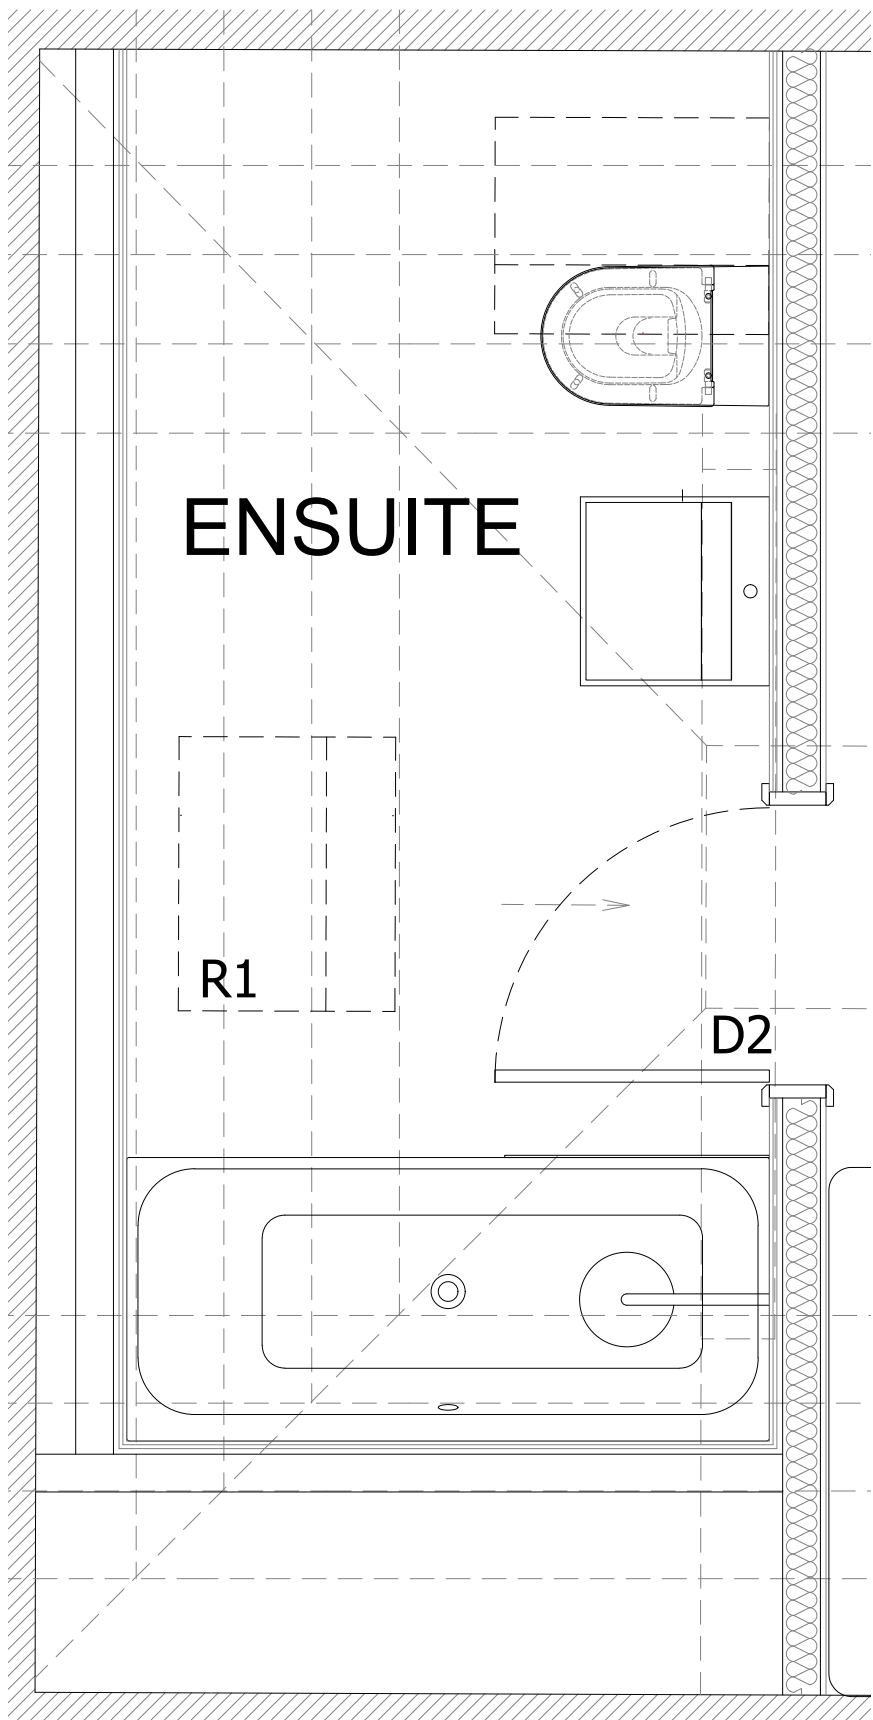

PLAN

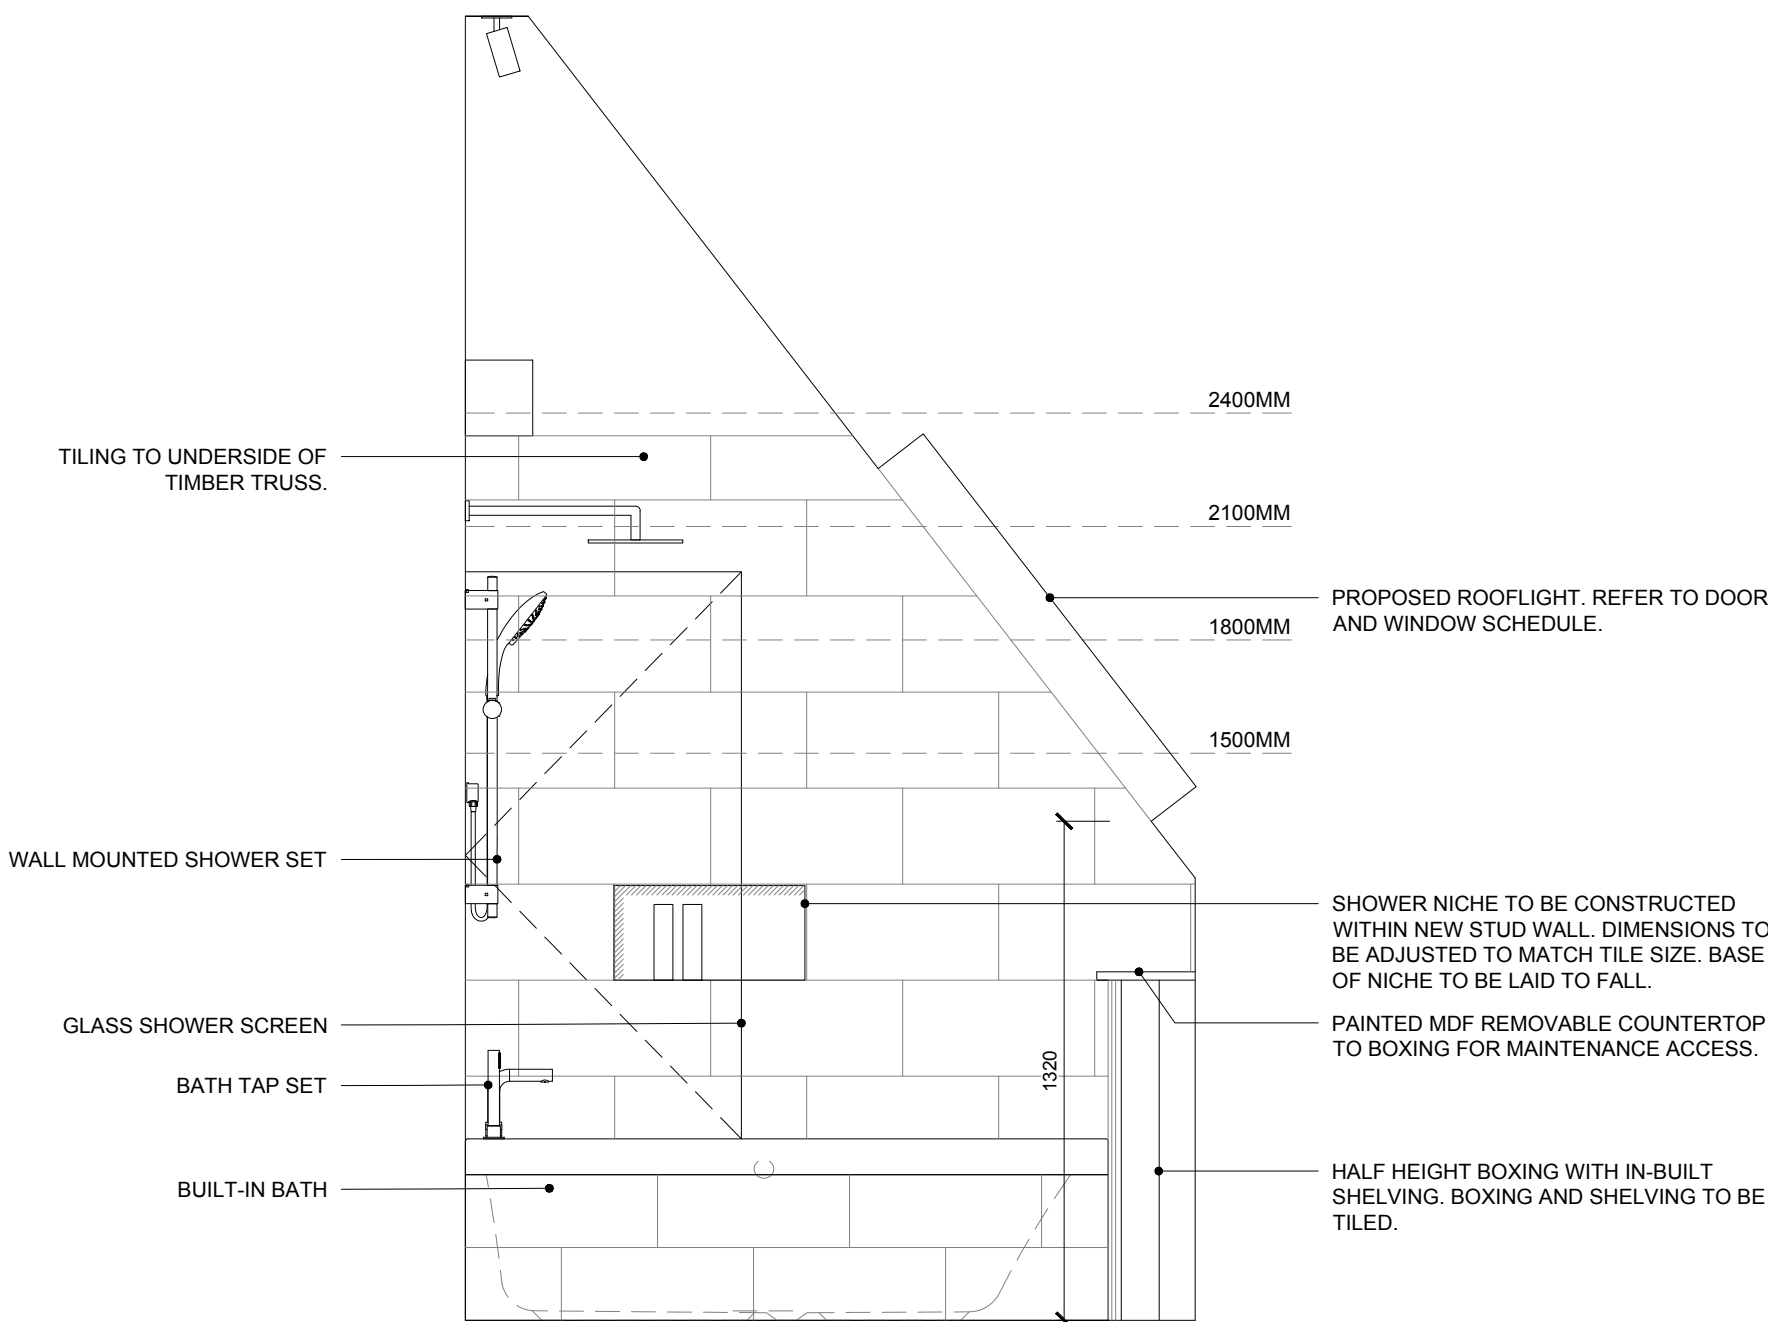 

ELEVATION C

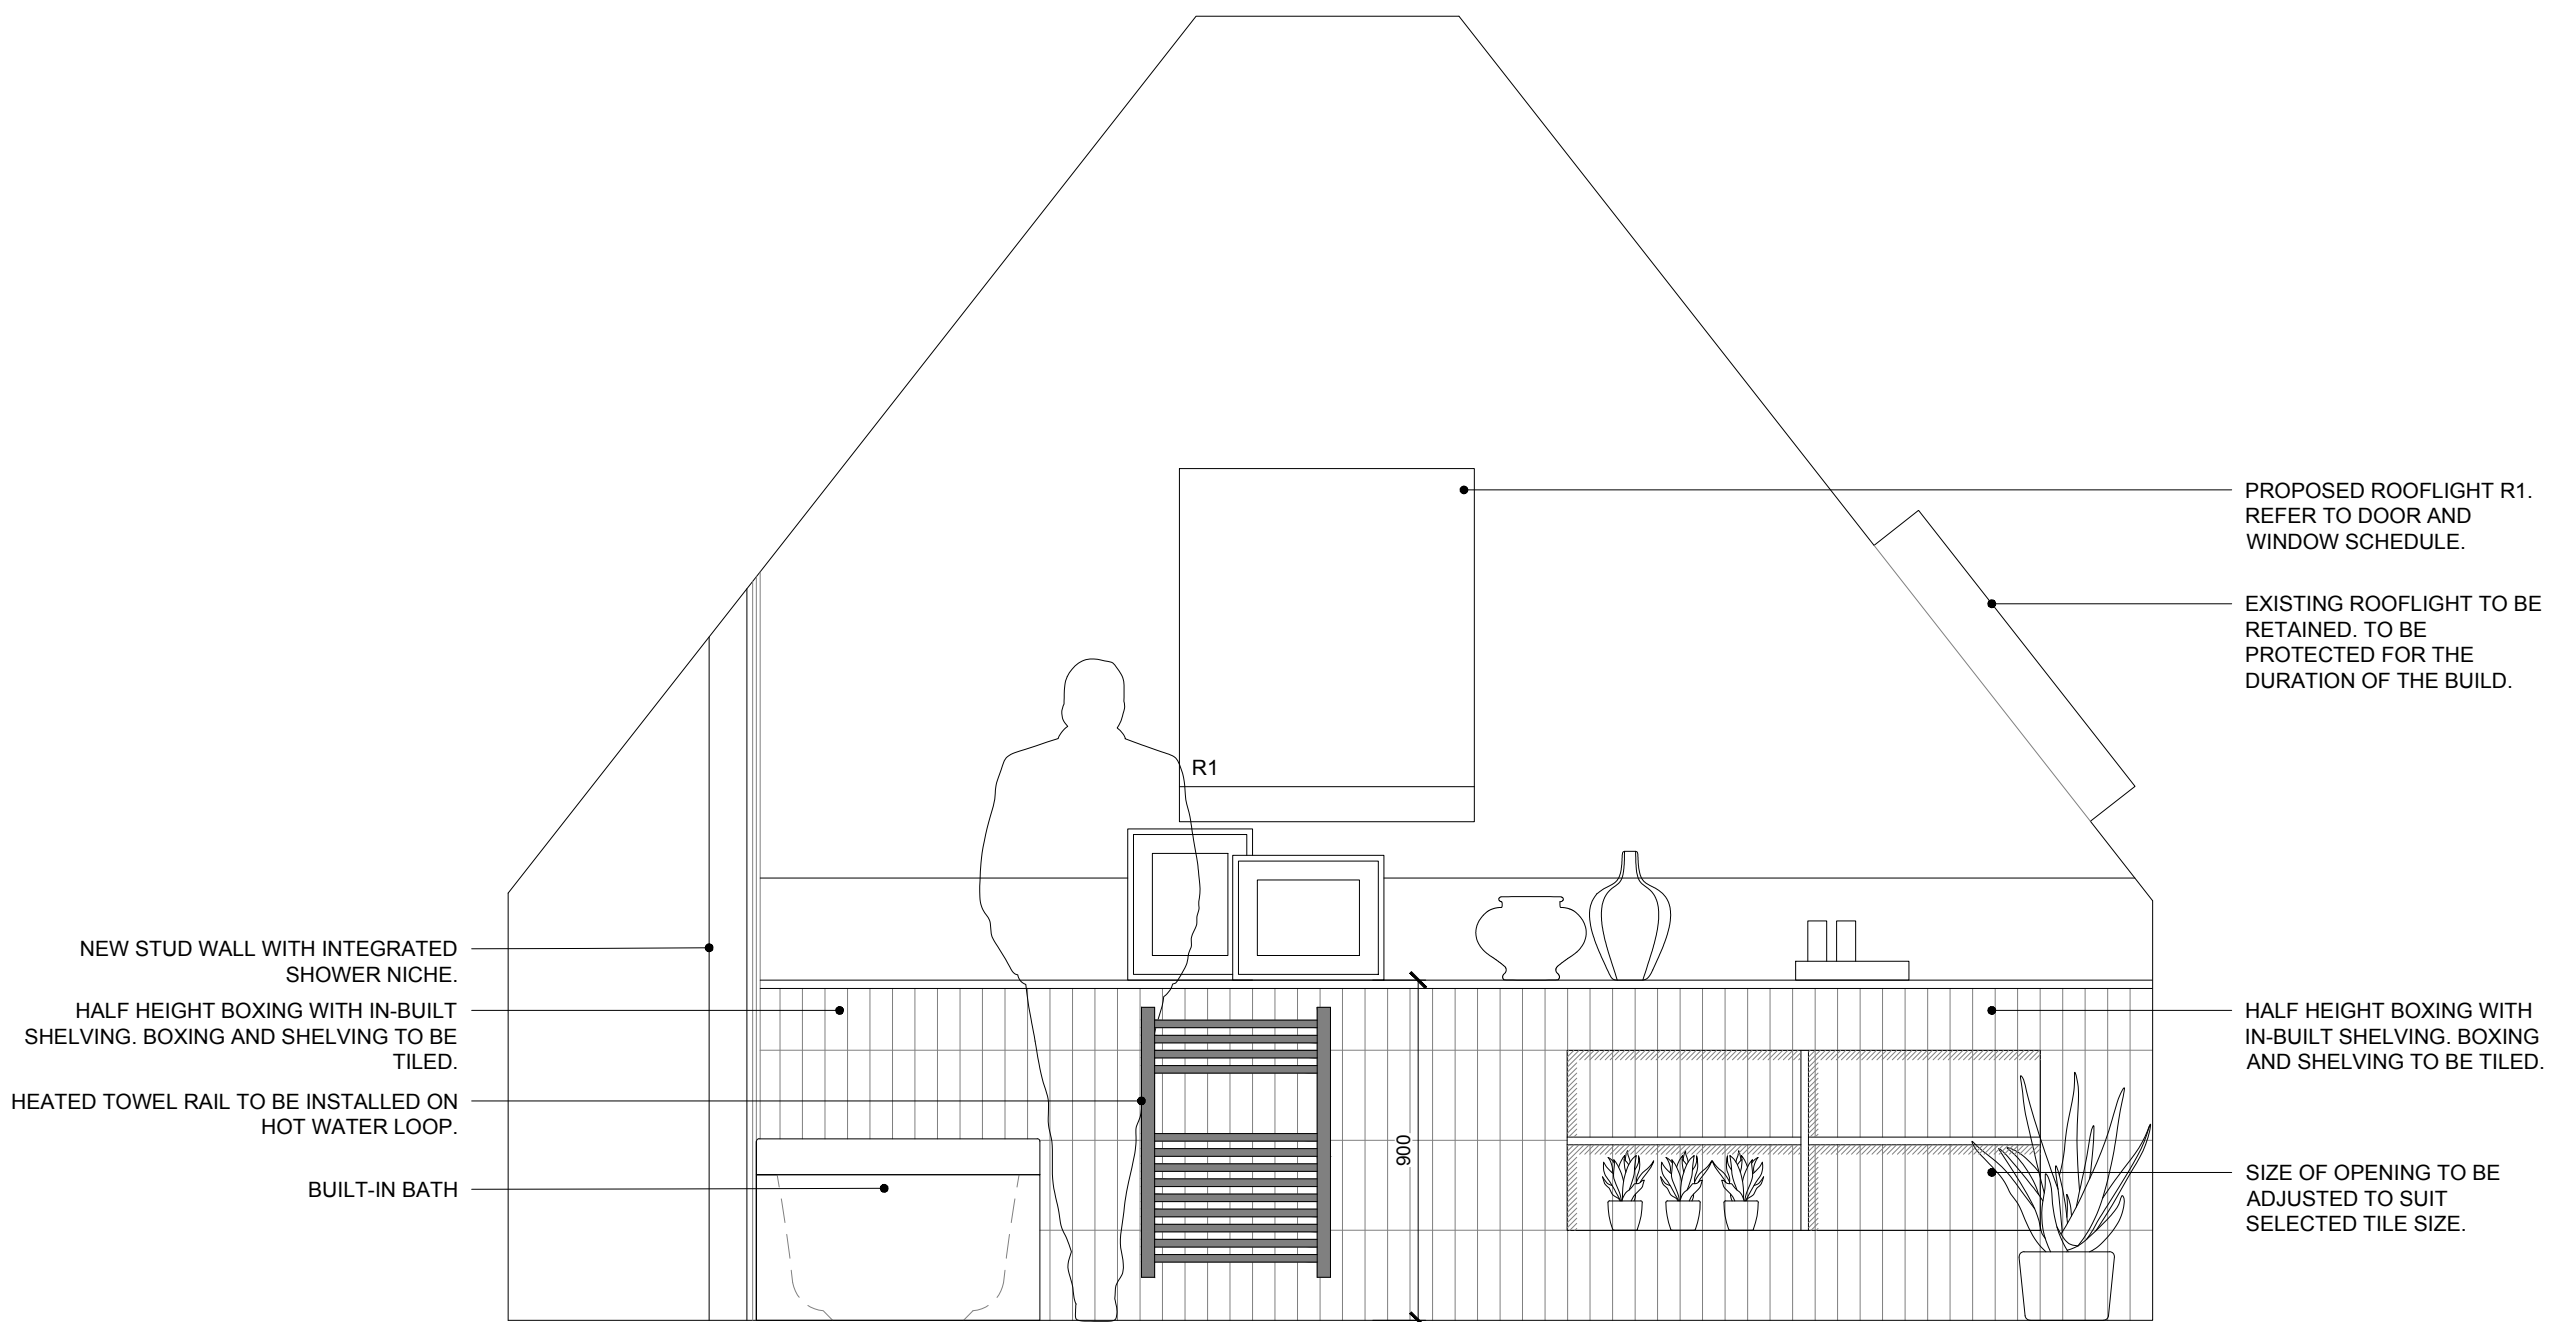

ELEVATION D


GENERAL NOTES - DETAILS

- THIS DRAWING IS TO BE READ IN CONJUNCTION WITH ALL GENERAL ARRANGEMENT, PROJECT DETAILS, SPECIFICATIONS AND CONSULTANTS DRAWINGS.
- UNLESS NOTED OTHERWISE, ALL DIMENSIONS ARE TO STRUCTURAL FACES AND/OR PARTITION STUDS.
- ALL ELEMENTS OF WORK TO BE INSTALLED ACCORDING TO THE APPROPRIATE MANUFACTURER'S INSTRUCTIONS.
- ALL EXTERNAL FINISHES TO BE IN ACCORDANCE WITH THE SPECIFICATION AND MATERIAL SCHEDULE.
- MOISTURE RESISTANT BOARD TO BE USED IN ALL BATHROOMS, KITCHENS AND EN-SUITE WET AREAS (GREEN BOARDS).


BUILDING CONTROL

Project	NORTH COTTAGE, READING ROAD, GORING RG8 0LL		
Drawing Title	PROPOSED INTERNAL ELEVATIONS GUEST BEDROOM 02 ENSUITE		
Date	Scale	Drawn by	Check by
JUNE 22	1:20 @ A1	CA	KB
Project No.	Drawing No.	Revision	
22.134	CO.3300	-	


Fineline
Architects

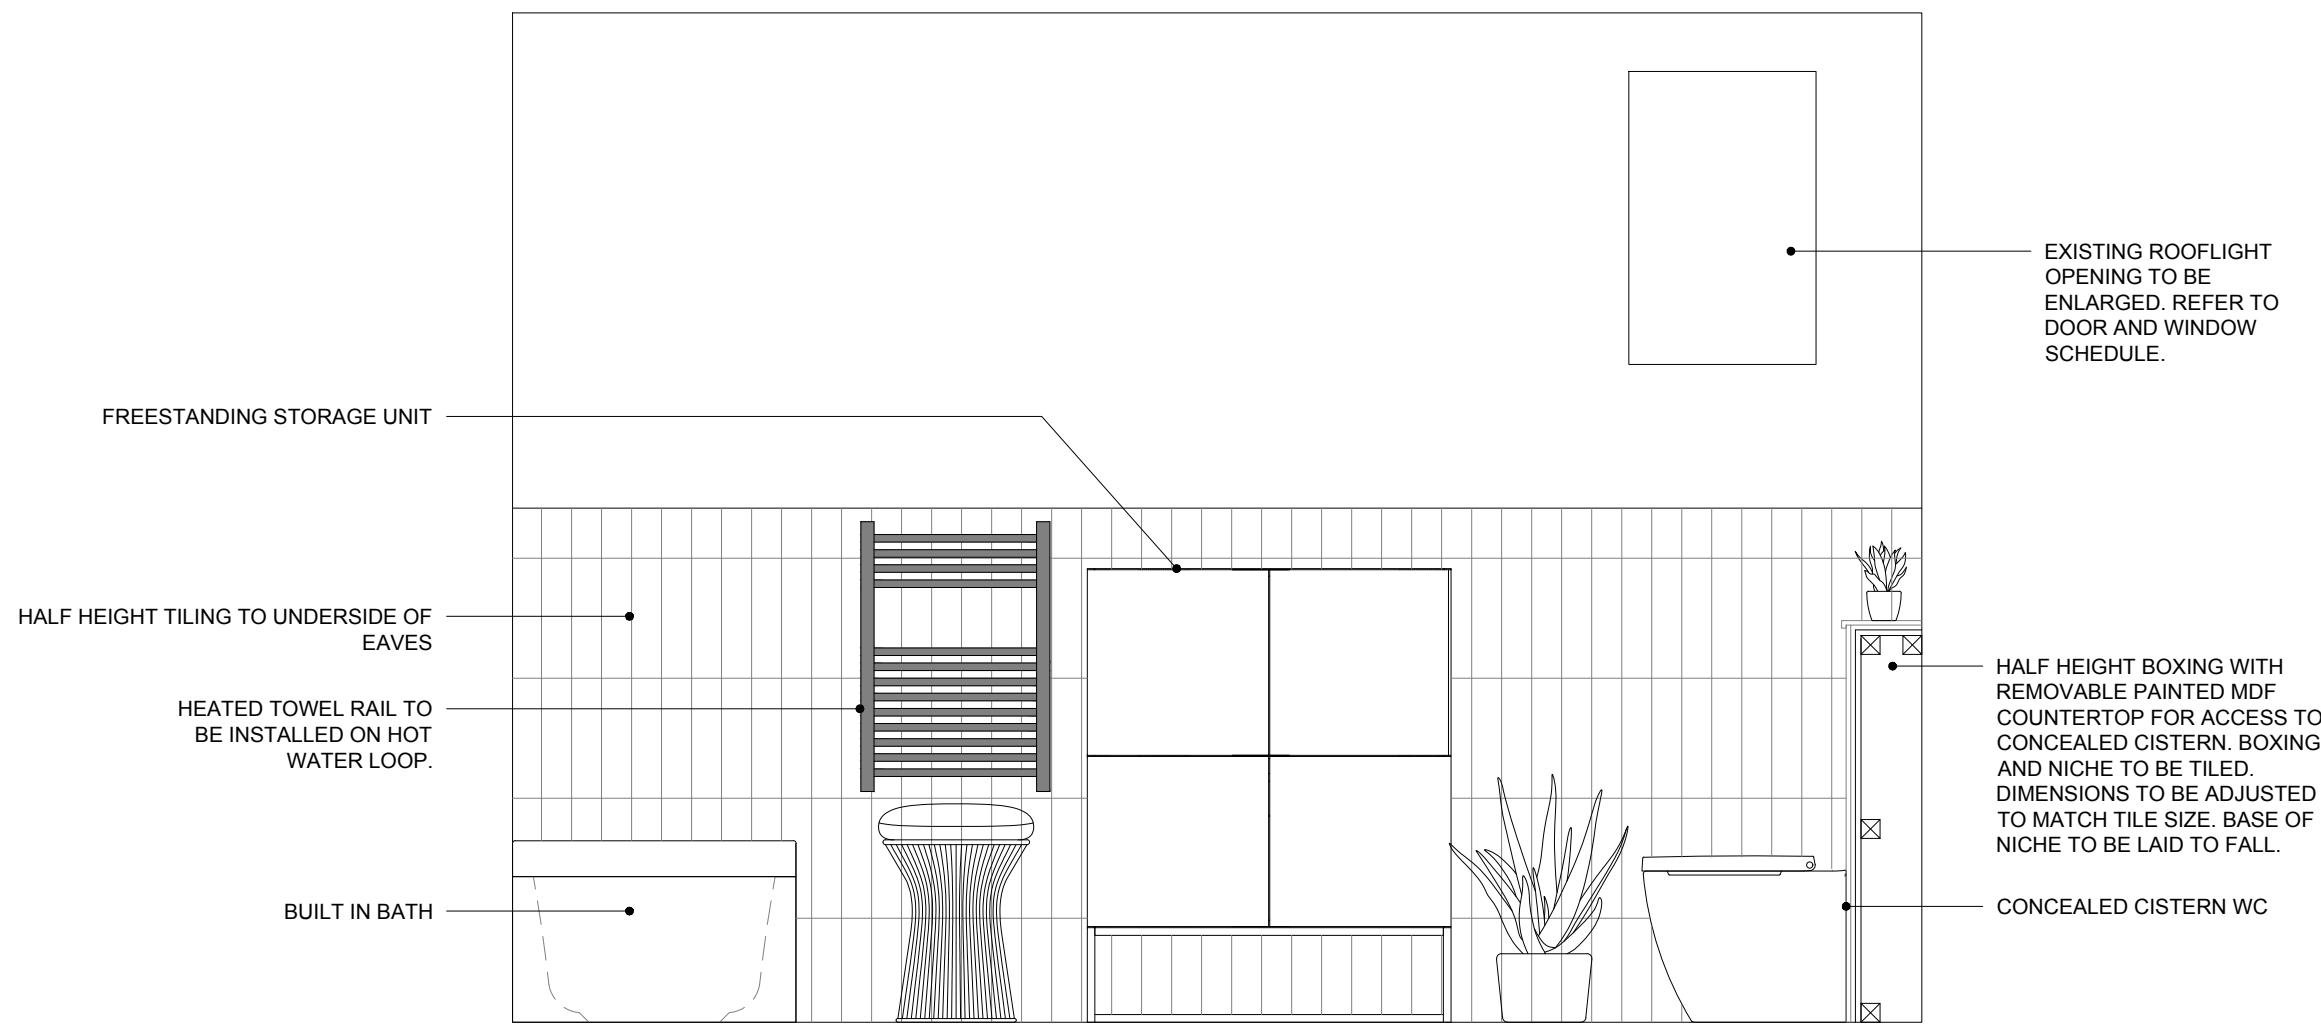


ELEVATION A

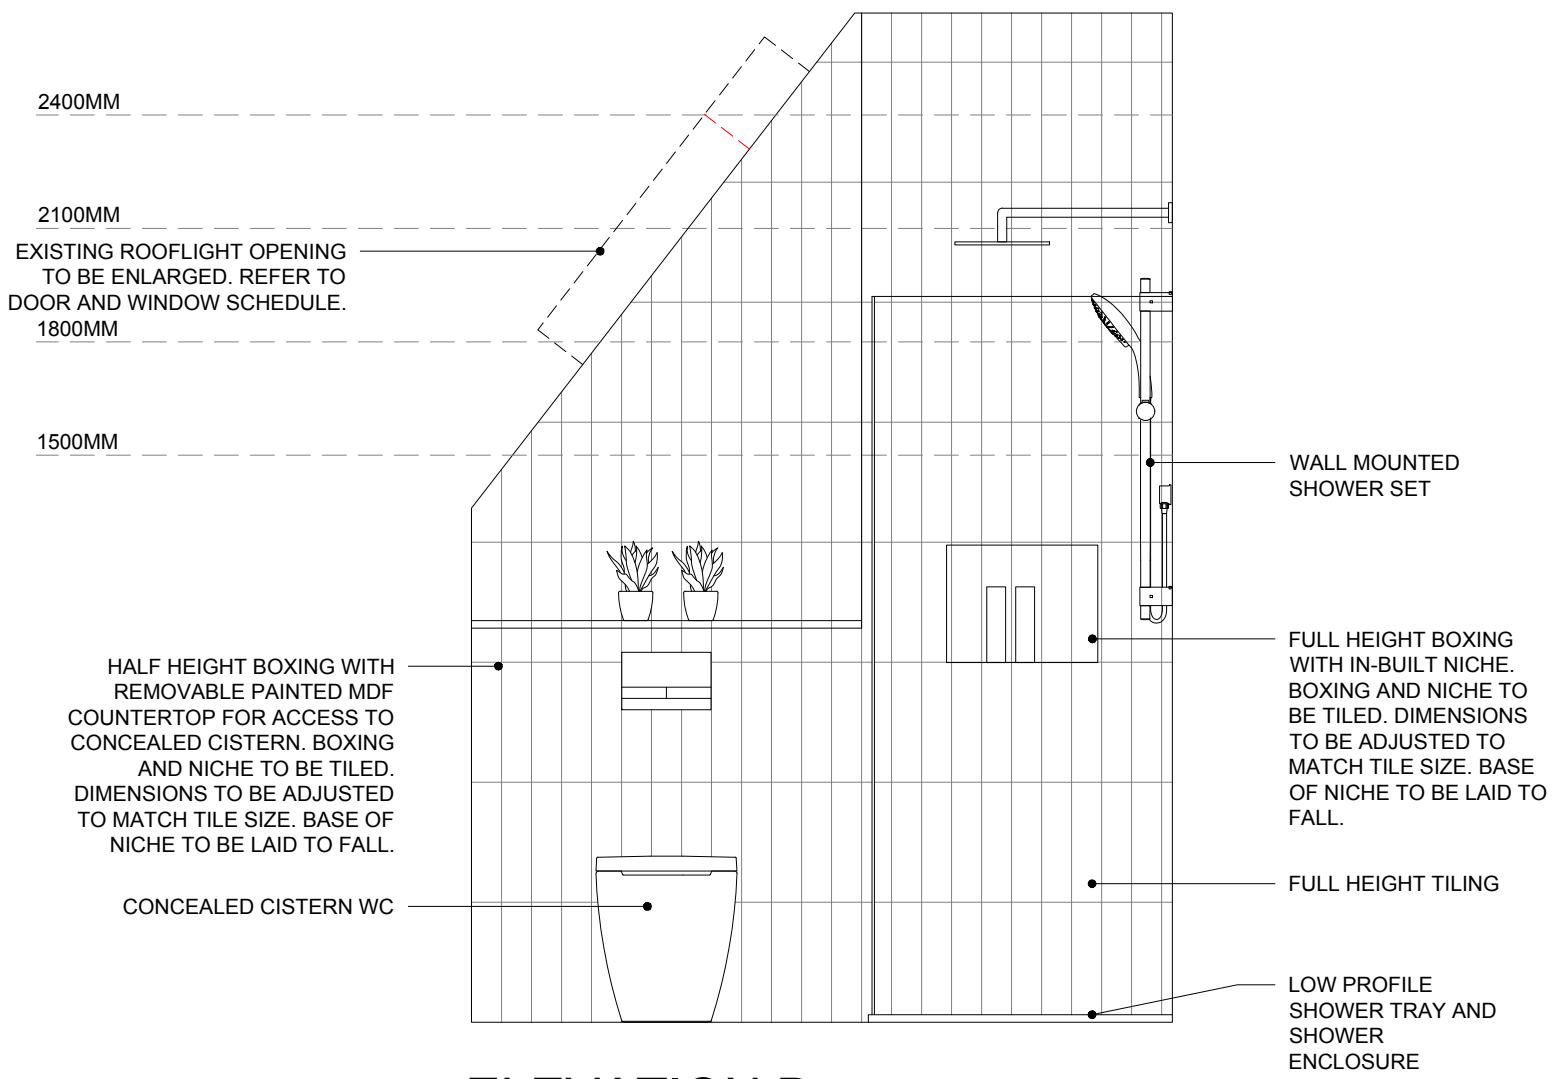


ELEVATION B

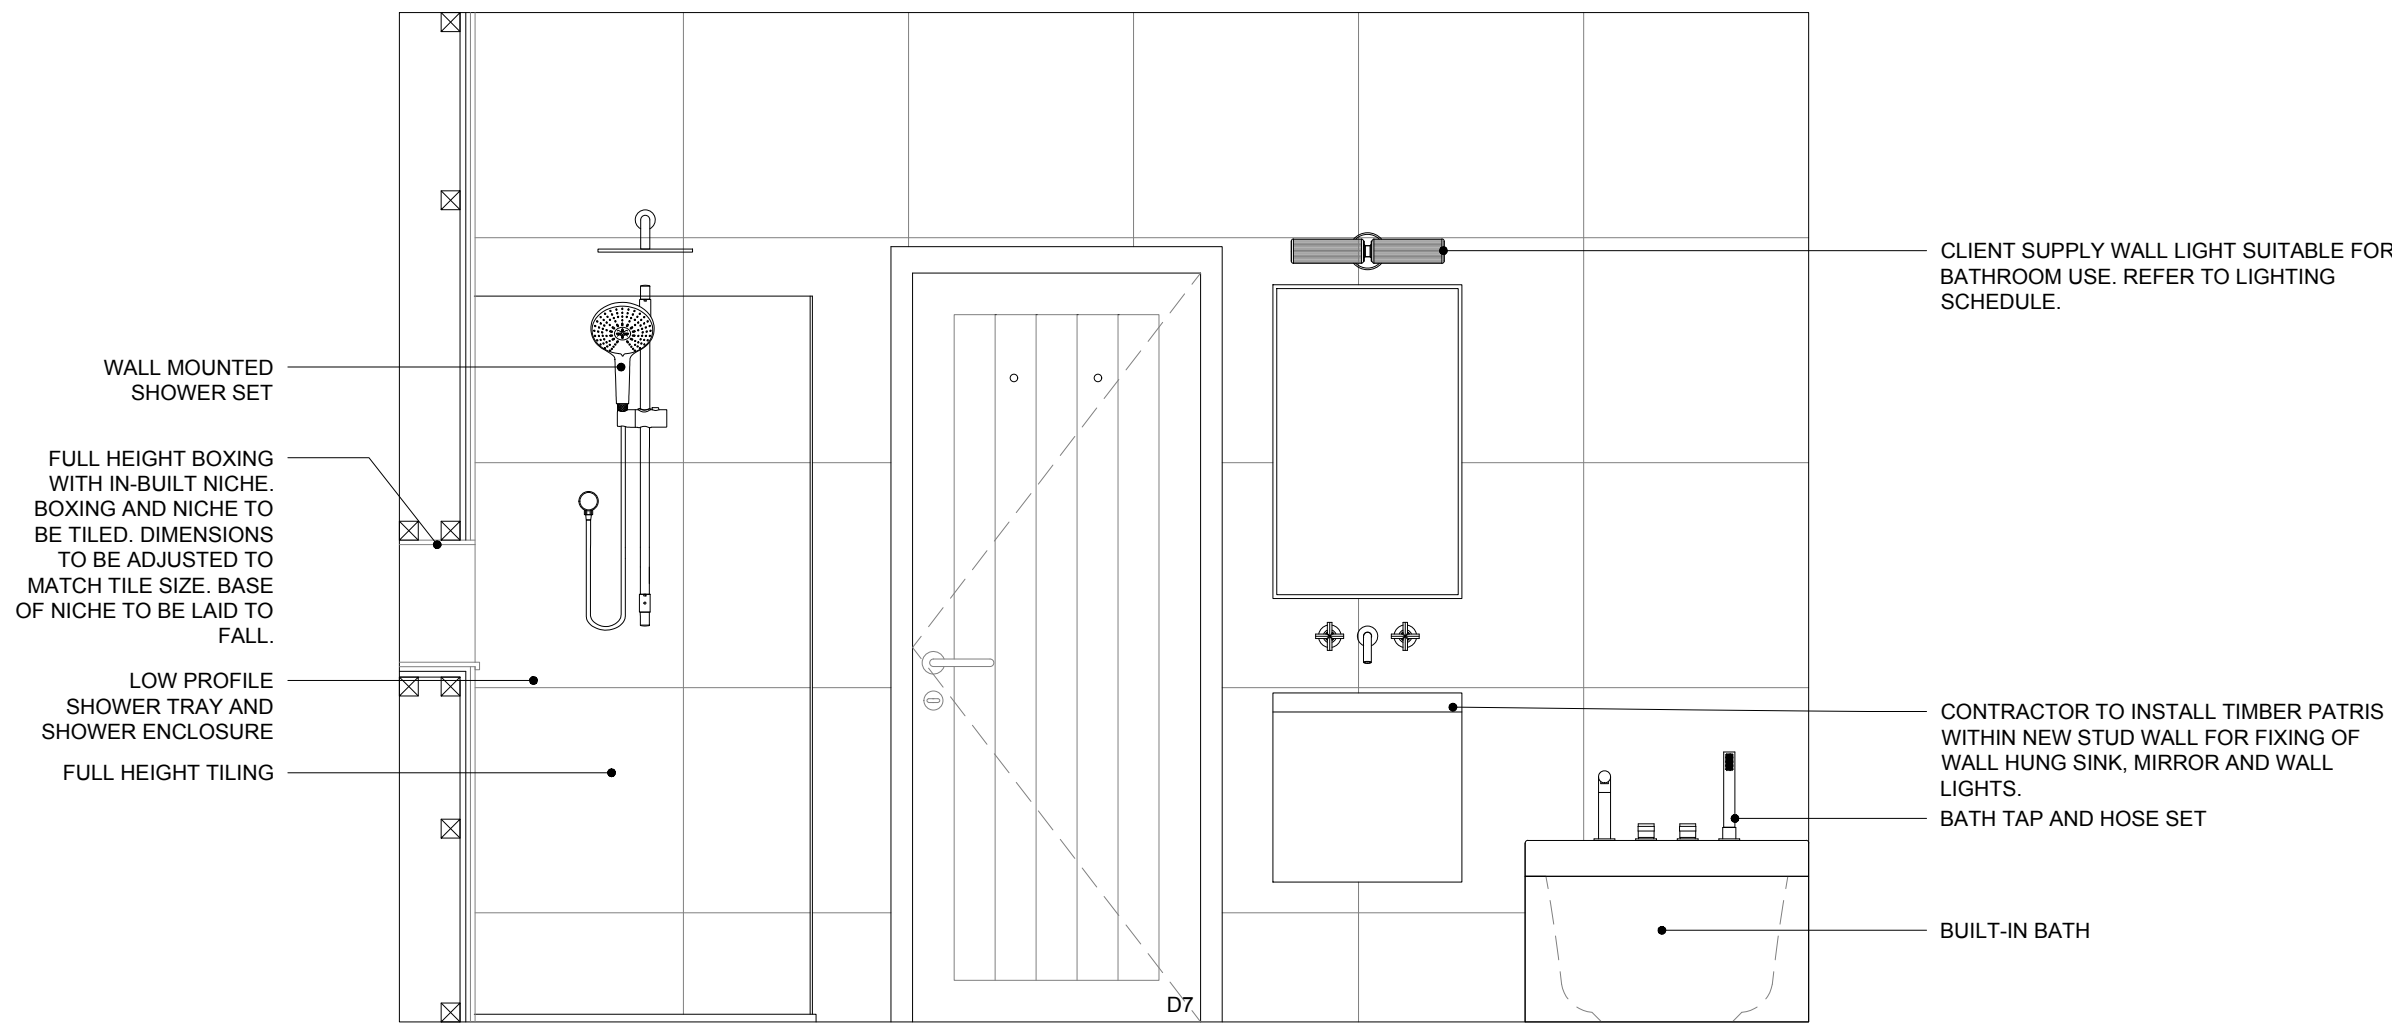

ELEVATION C

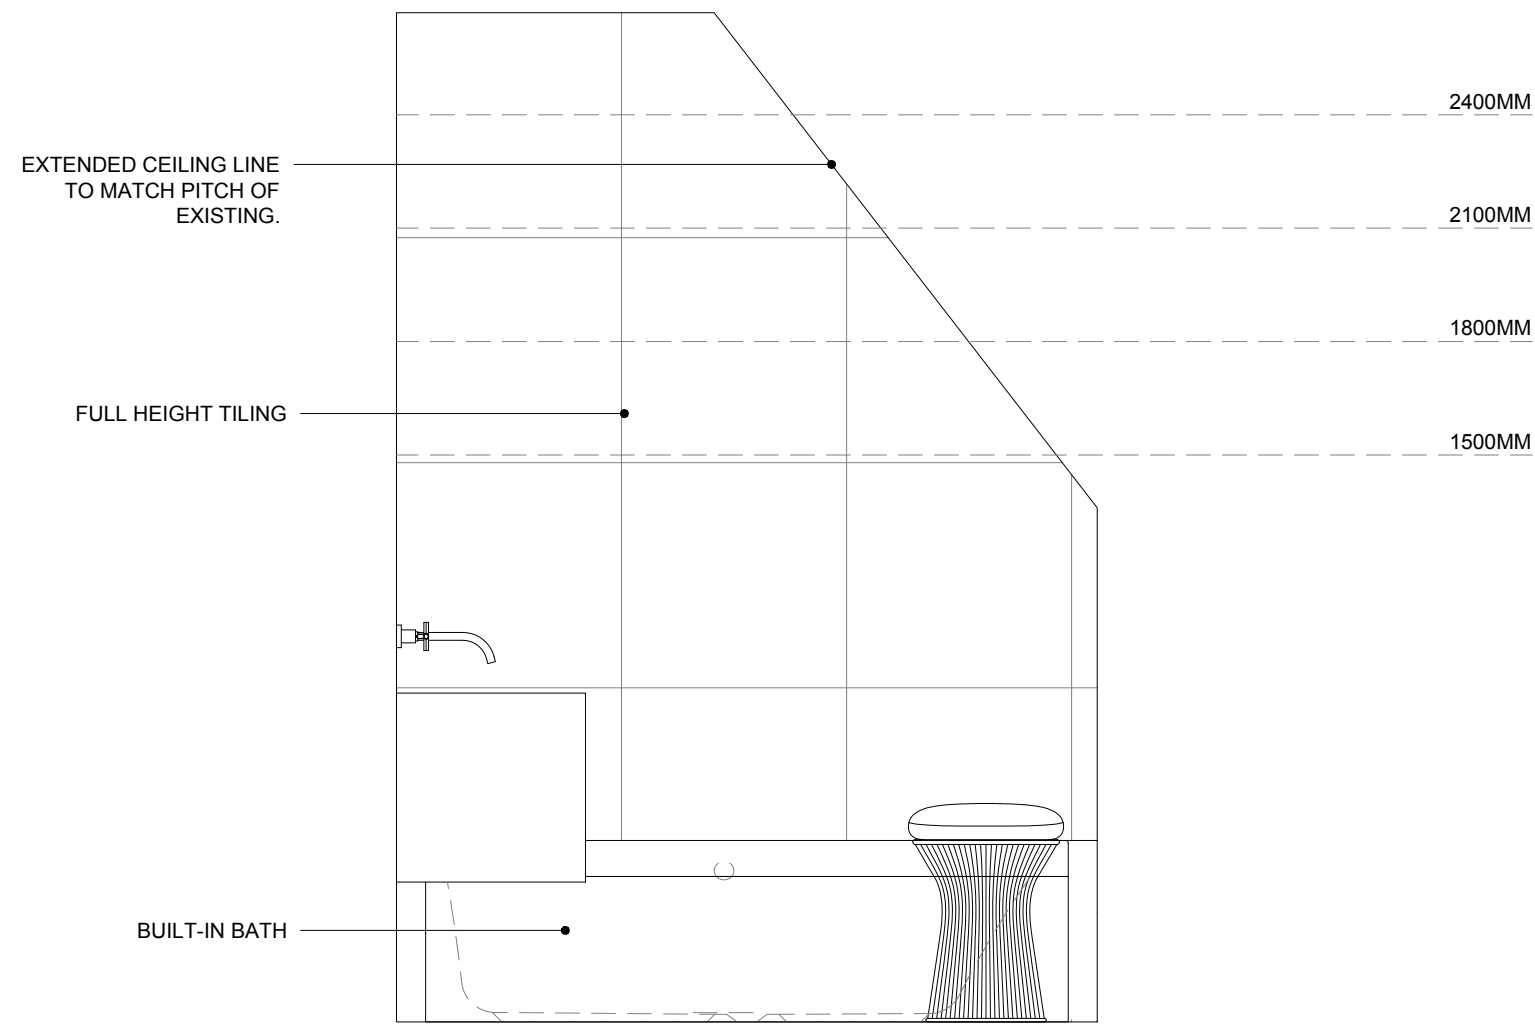

ELEVATION D

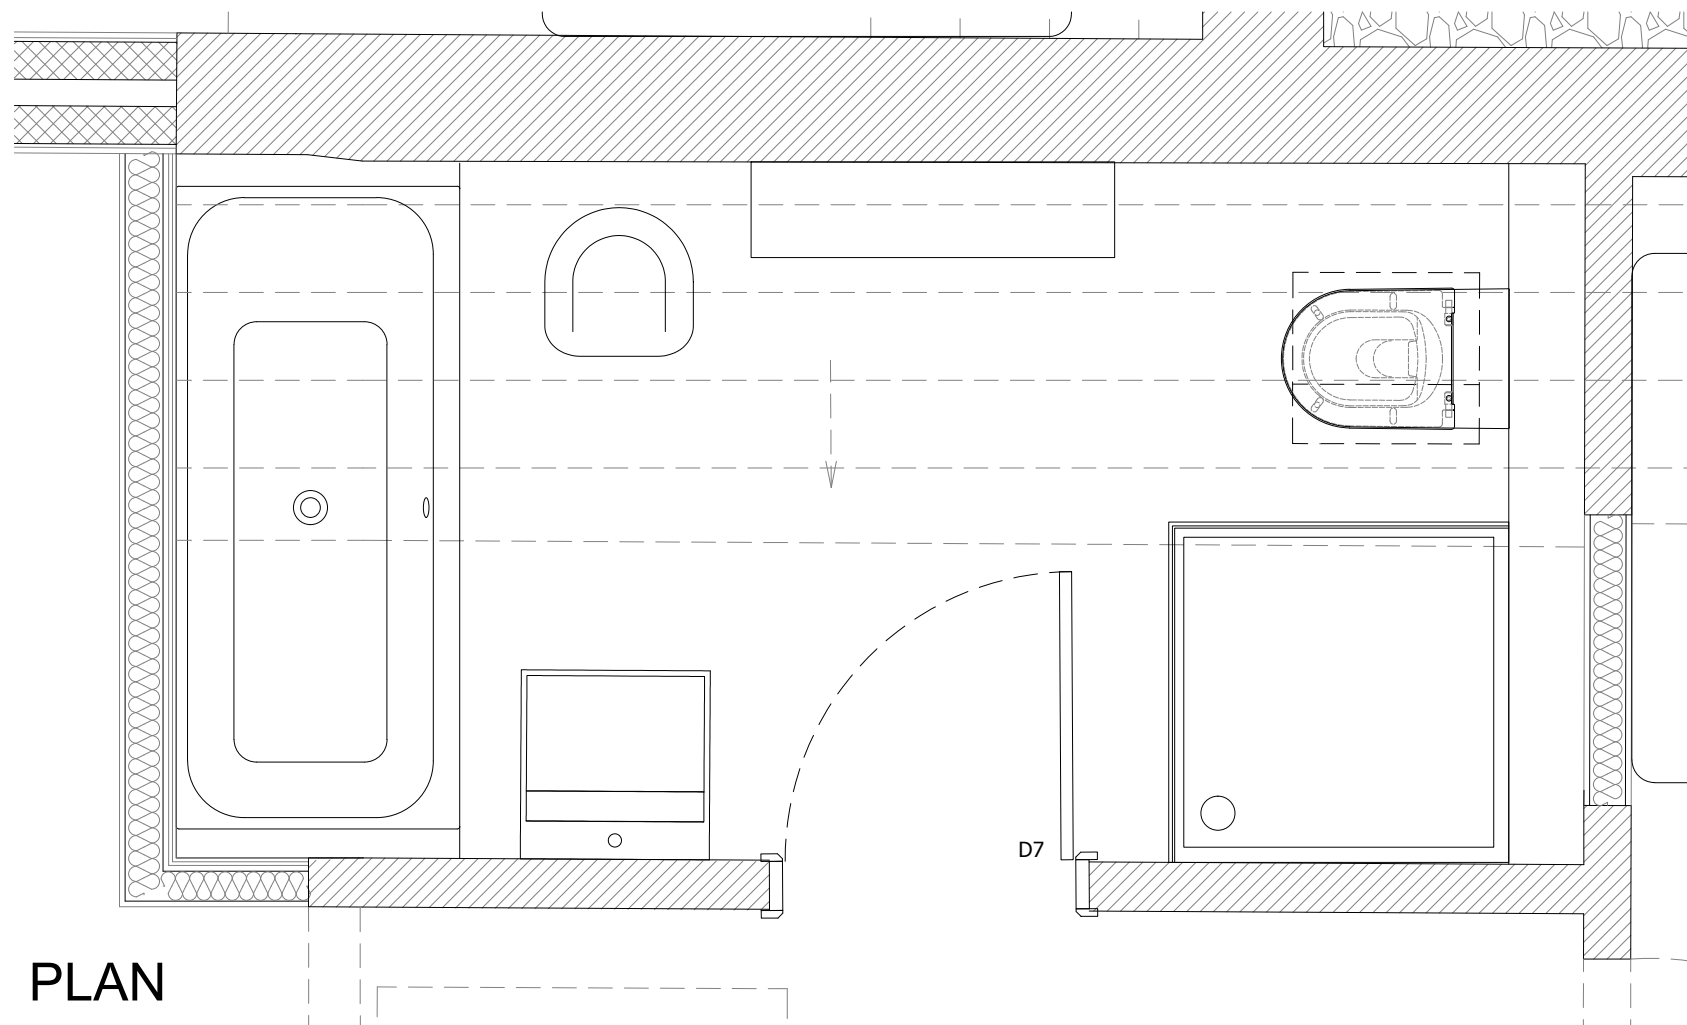

PLAN

SCALE 1:20

0 0.5 1 1.5 2 (M.)

GENERAL NOTES - DETAILS

- THIS DRAWING IS TO BE READ IN CONJUNCTION WITH ALL GENERAL ARRANGEMENT, PROJECT DETAILS, SPECIFICATIONS AND CONSULTANTS DRAWINGS.
- UNLESS NOTED OTHERWISE, ALL DIMENSIONS ARE TO STRUCTURAL FACES AND/OR PARTITION STUDS.
- ALL ELEMENTS OF WORK TO BE INSTALLED ACCORDING TO THE APPROPRIATE MANUFACTURER'S INSTRUCTIONS.
- ALL EXTERNAL FINISHES TO BE IN ACCORDANCE WITH THE SPECIFICATION AND MATERIAL SCHEDULE.
- MOISTURE RESISTANT BOARD TO BE USED IN ALL BATHROOMS, KITCHENS AND EN-SUITE WET AREAS (GREEN BOARDS).

BUILDING CONTROL

Project
NORTH COTTAGE, READING ROAD,
GORING RG8 0LL


Drawing Title
PROPOSED INTERNAL ELEVATIONS
FAMILY BATHROOM

Date	Scale	Drawn by	Check by
JUNE 22	1:20 @ A1	CA	KB
Project No.	Drawing No.	Revision	
22.134	CO.3301	-	


Fineline
Architects

T. 07825 615 255
E. info@finelinearchitects.co.uk
W. www.finelinearchitects.co.uk


Revision	Issue Date	Dm	Chk

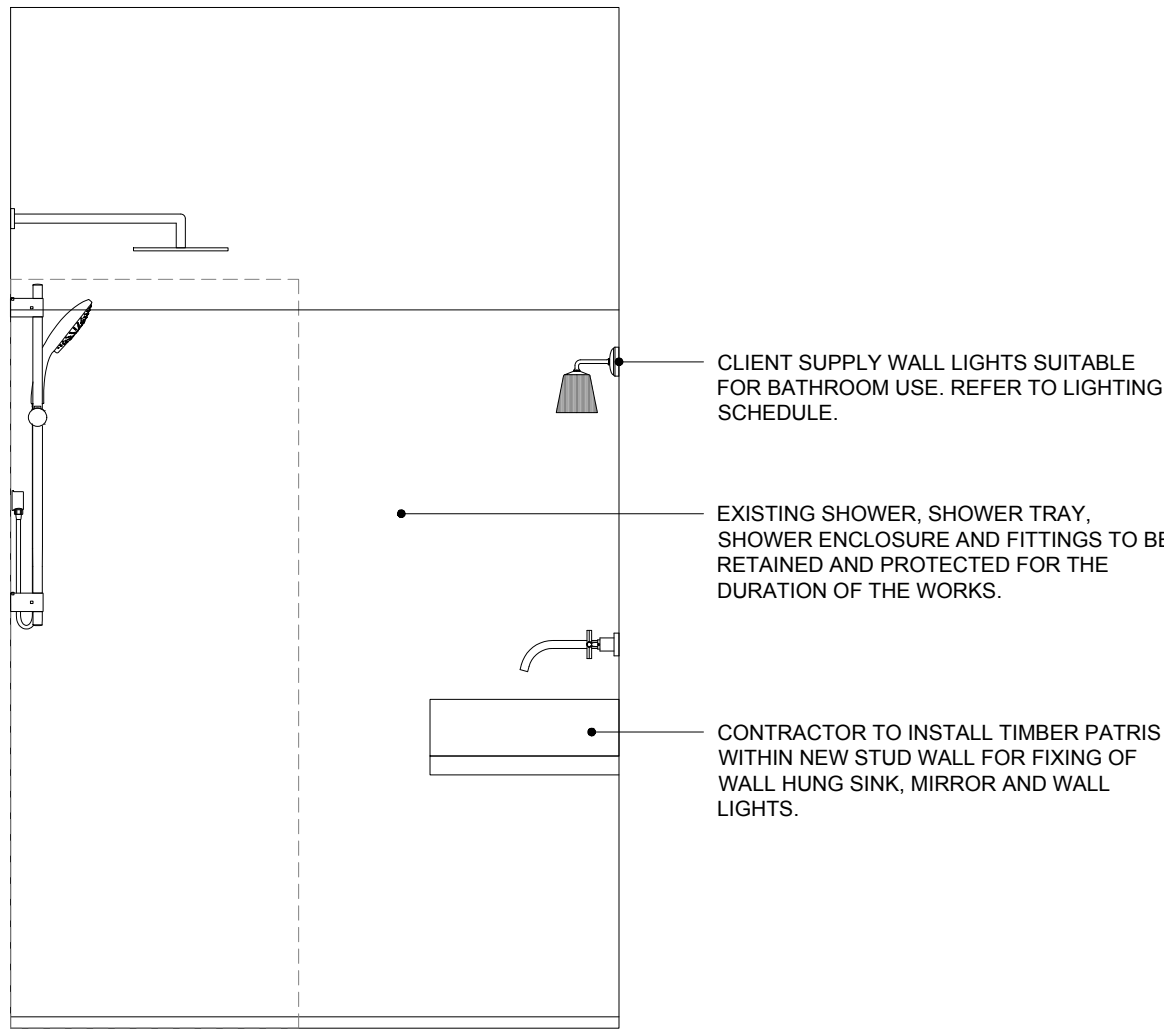


ELEVATION A

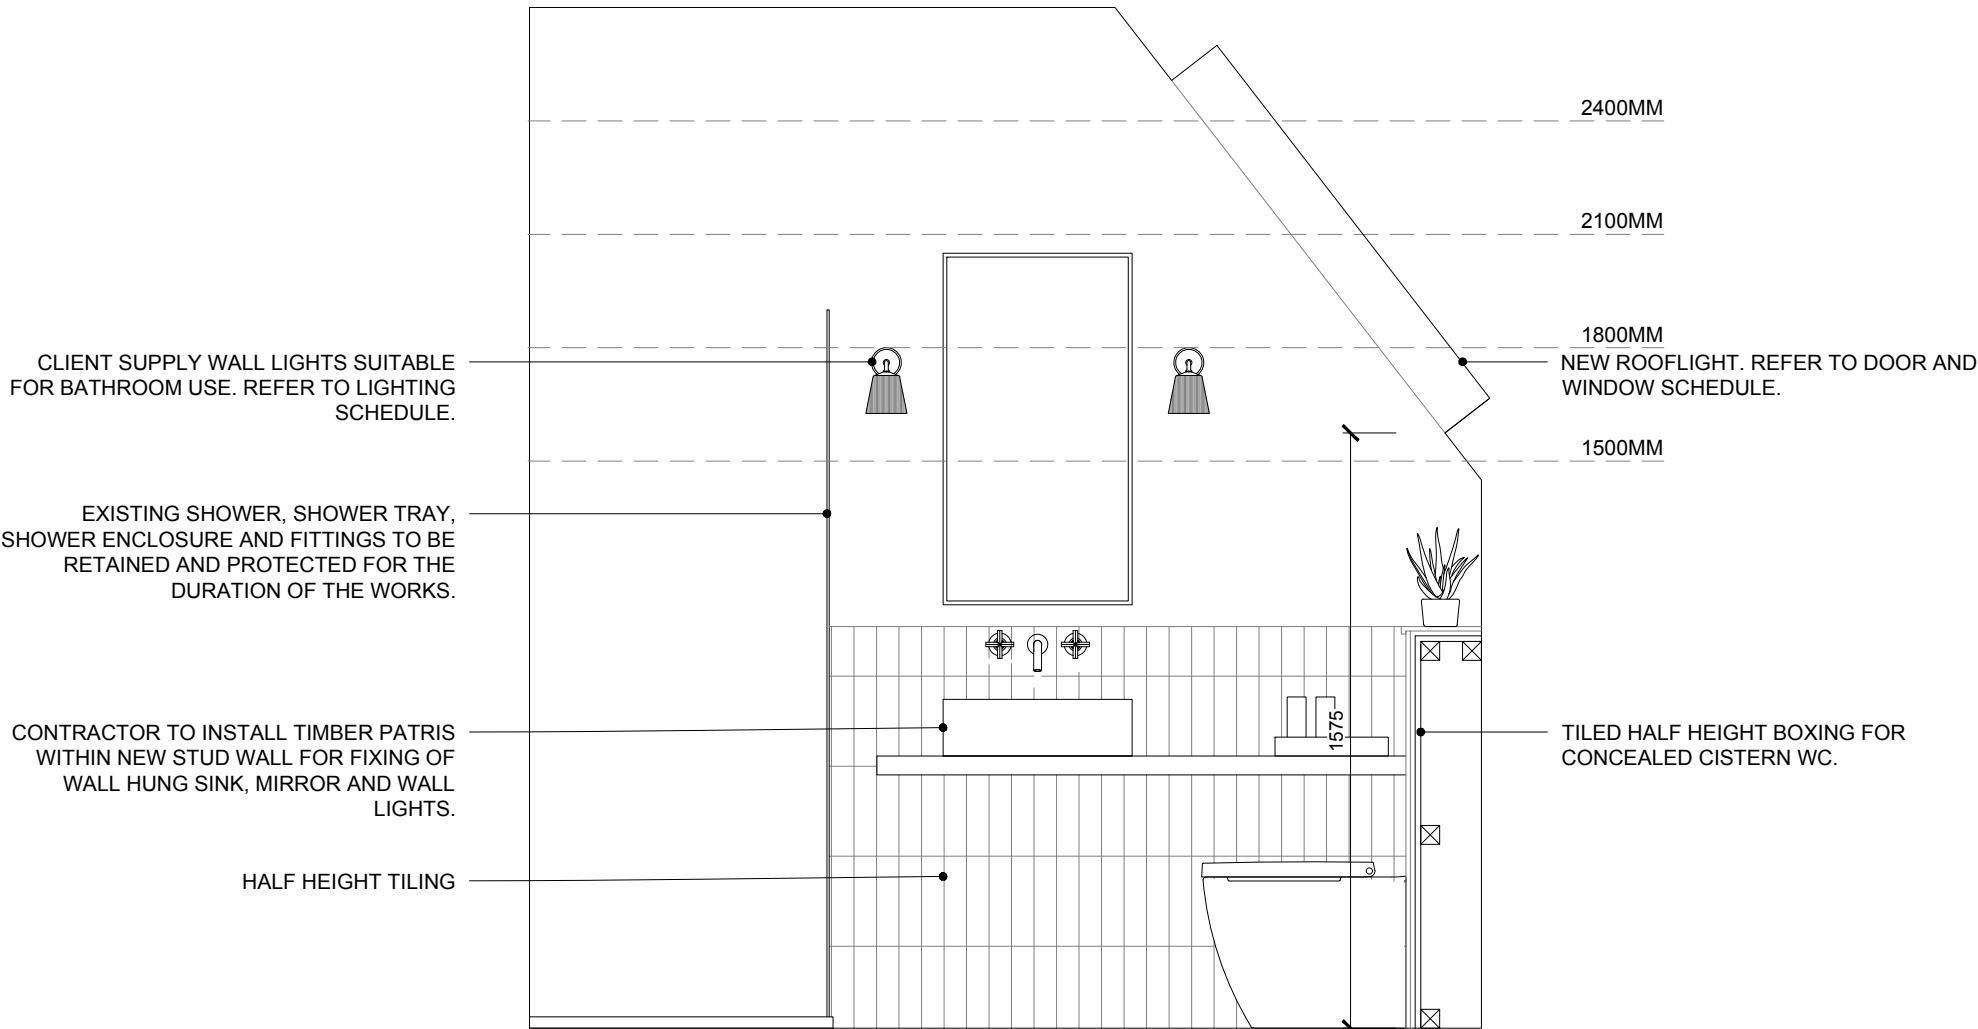


ELEVATION B

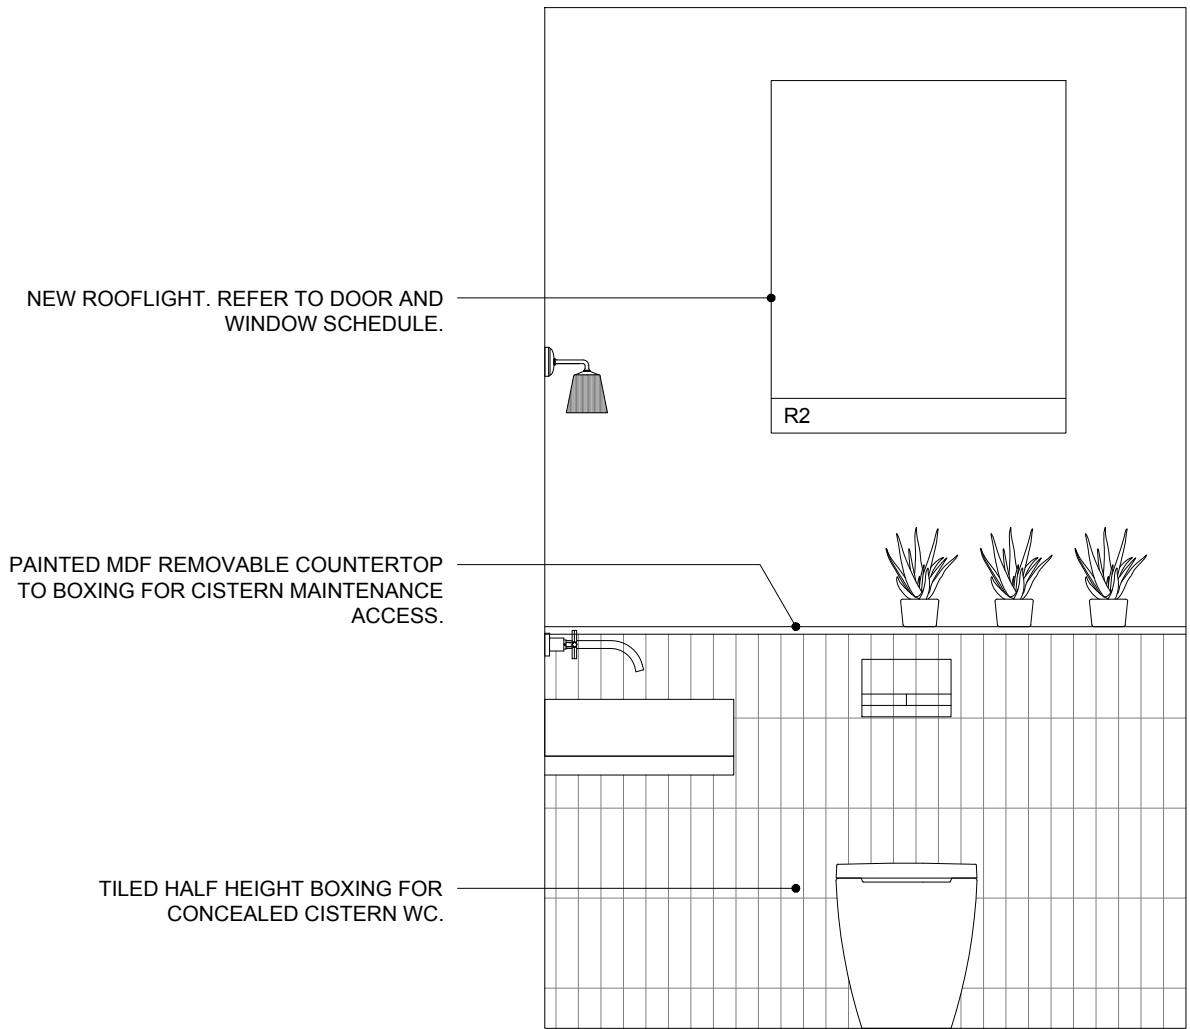

ELEVATION C

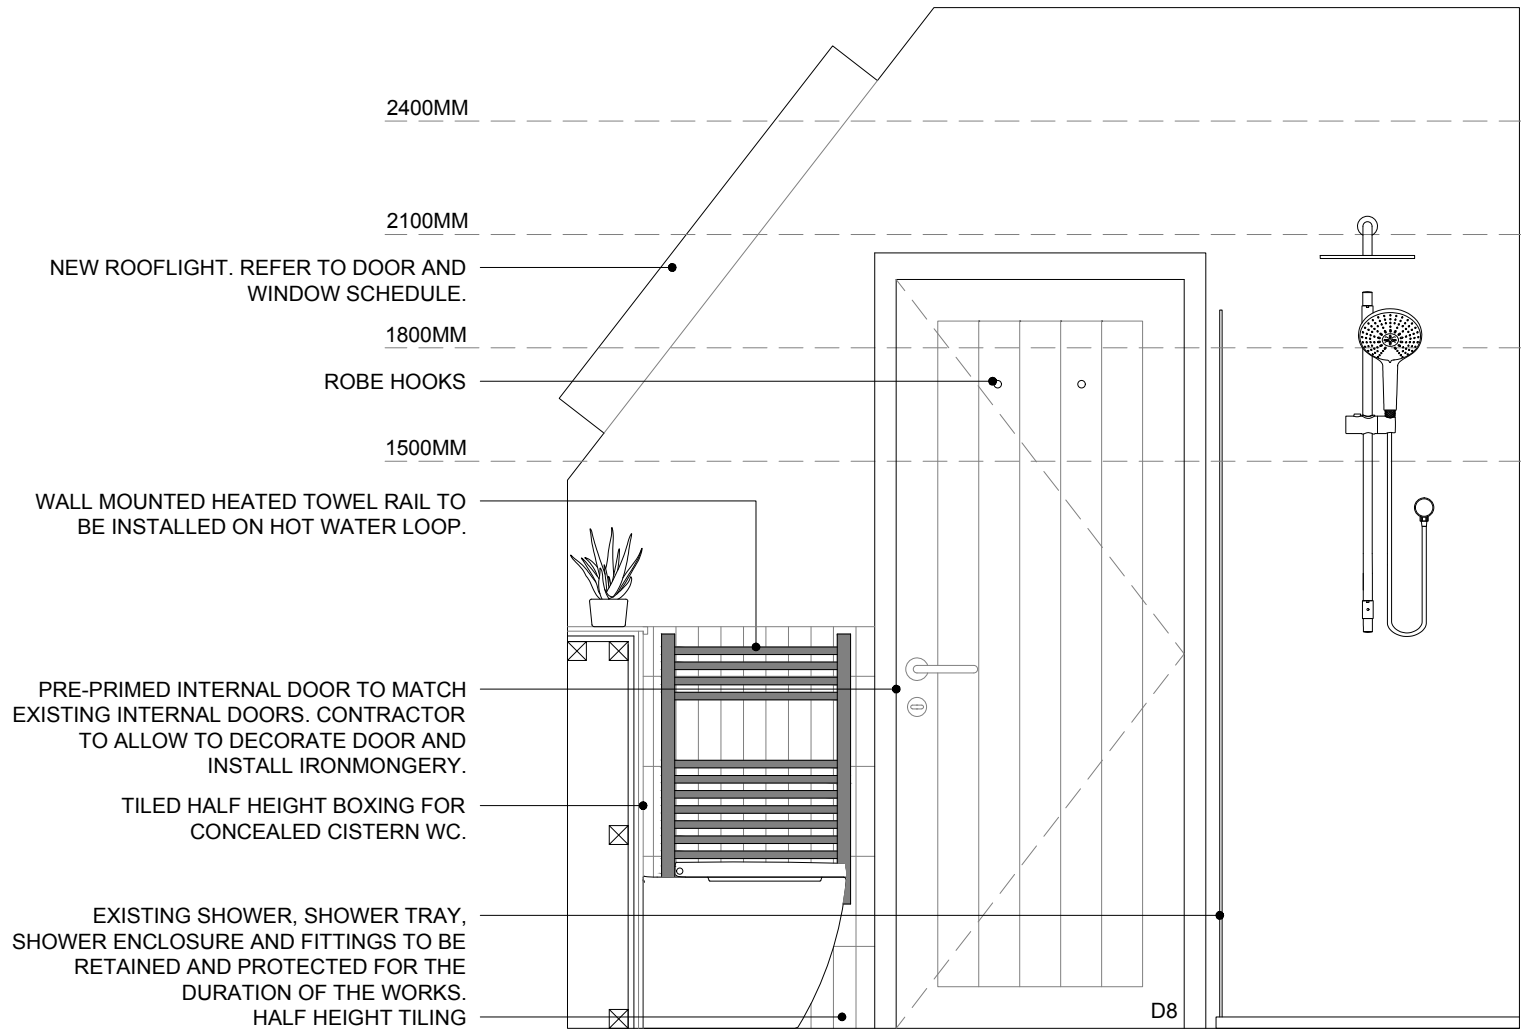

ELEVATION D

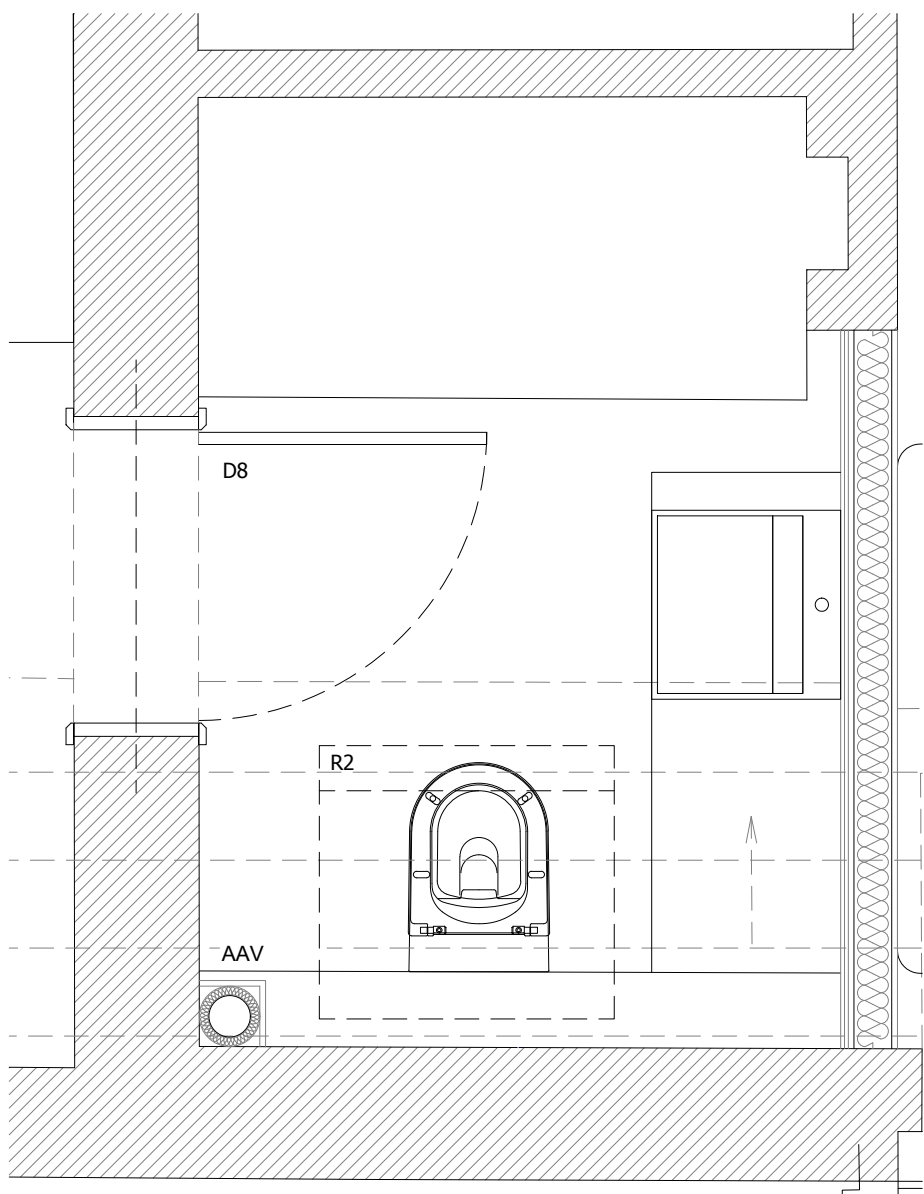

PLAN

GENERAL NOTES - DETAILS

- THIS DRAWING IS TO BE READ IN CONJUNCTION WITH ALL GENERAL ARRANGEMENT, PROJECT DETAILS, SPECIFICATIONS AND CONSULTANTS DRAWINGS.
- UNLESS NOTED OTHERWISE, ALL DIMENSIONS ARE TO STRUCTURAL FACES AND/OR PARTITION STUDS.
- ALL ELEMENTS OF WORK TO BE INSTALLED ACCORDING TO THE APPROPRIATE MANUFACTURER'S INSTRUCTIONS.
- ALL EXTERNAL FINISHES TO BE IN ACCORDANCE WITH THE SPECIFICATION AND MATERIAL SCHEDULE.
- MOISTURE RESISTANT BOARD TO BE USED IN ALL BATHROOMS, KITCHENS AND EN-SUITE WET AREAS (GREEN BOARDS).

BUILDING CONTROL

Project
NORTH COTTAGE, READING ROAD,
GORING RG8 0LL


Drawing Title
PROPOSED INTERNAL ELEVATIONS
GUEST BEDROOM 01 ENSUITE

Date	Scale	Drawn by	Check by
JUNE 22	1:20 @ A1	CA	KB
Project No.	Drawing No.	Revision	
22.134	CO.3302	-	


Fineline
Architects

T. 07825 615 255
E. info@finelinearchitects.co.uk
W. www.finelinearchitects.co.uk


Revision	Issue Date	Dm	Chk

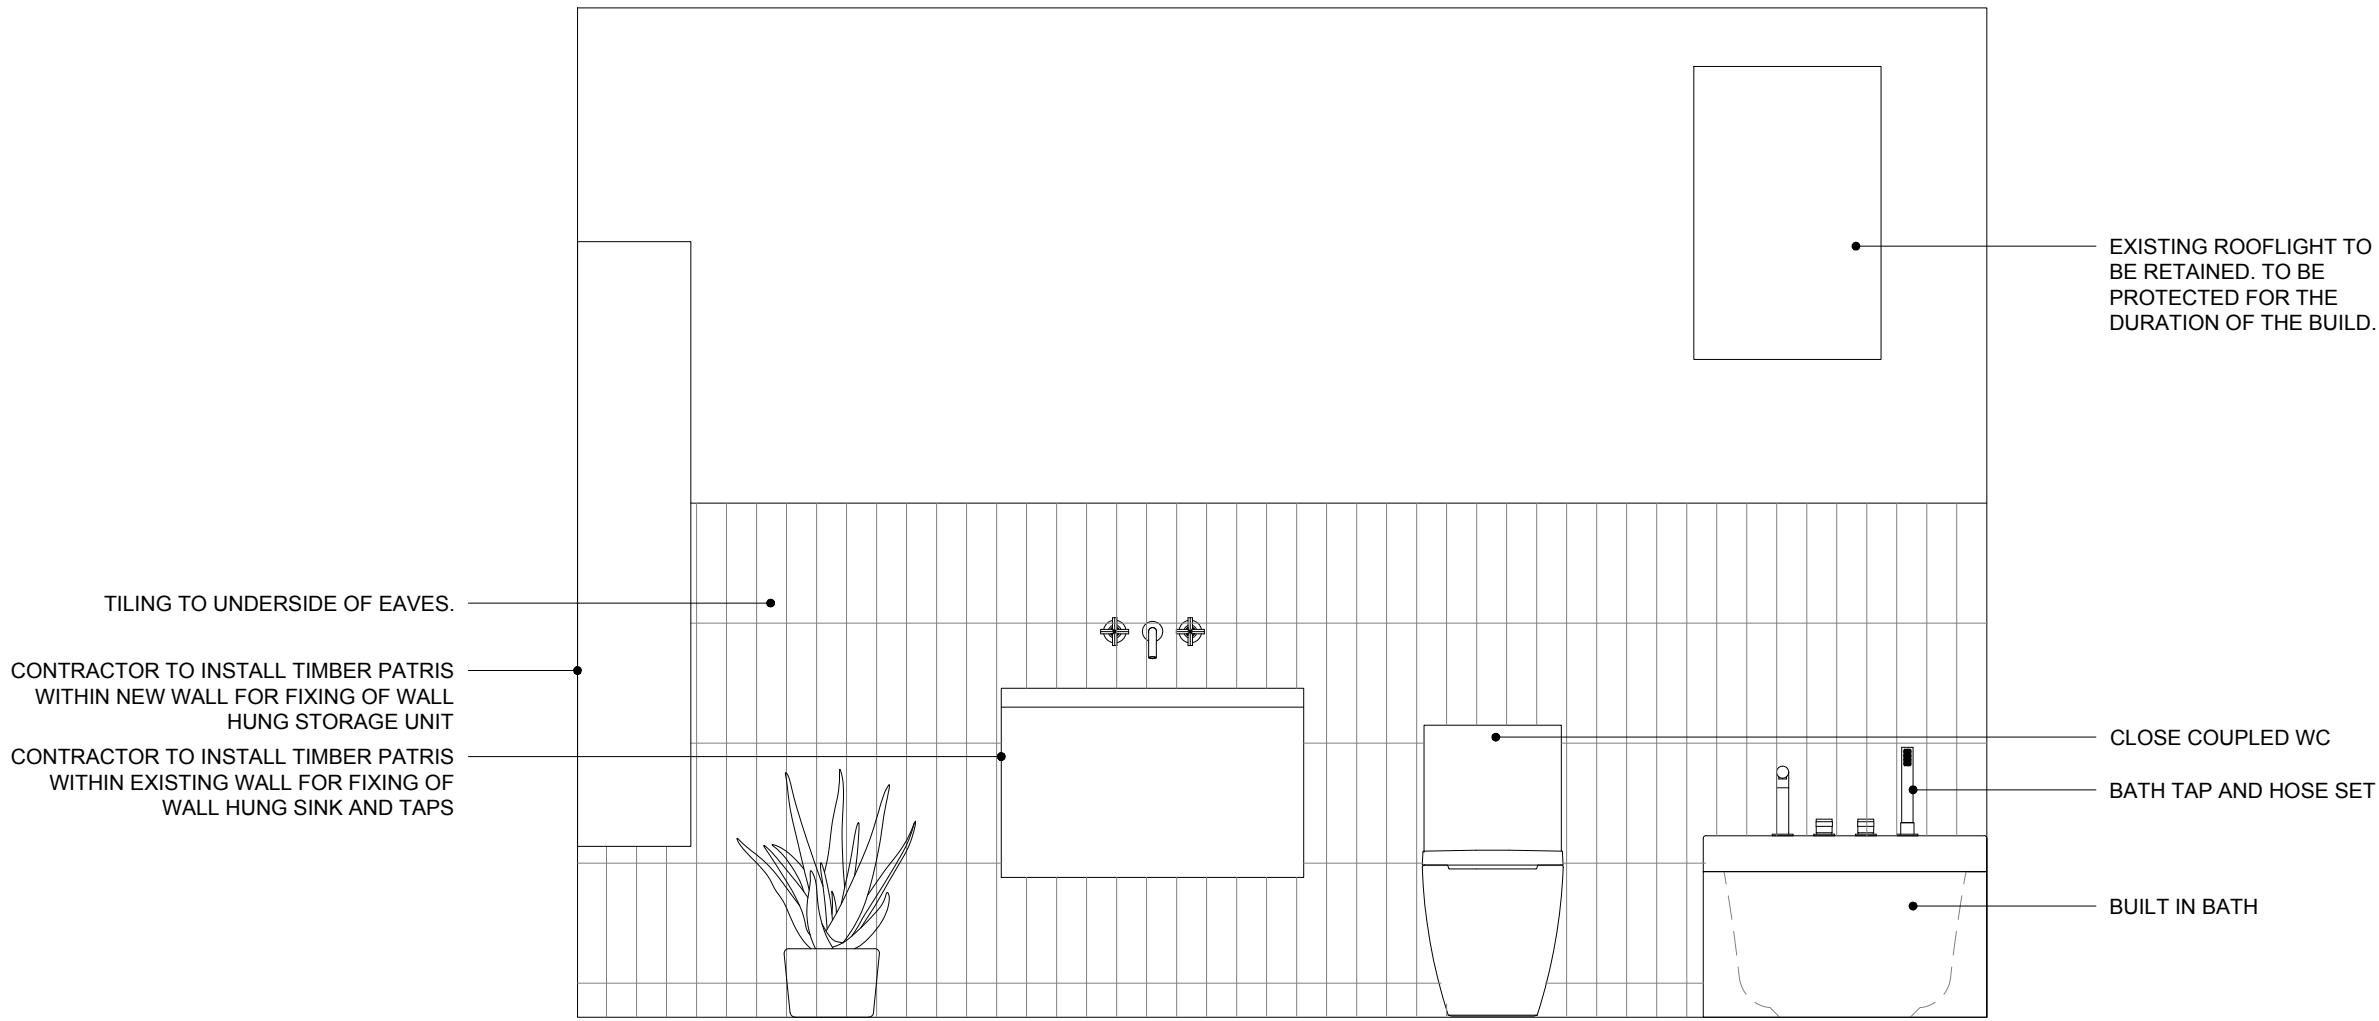


ELEVATION A

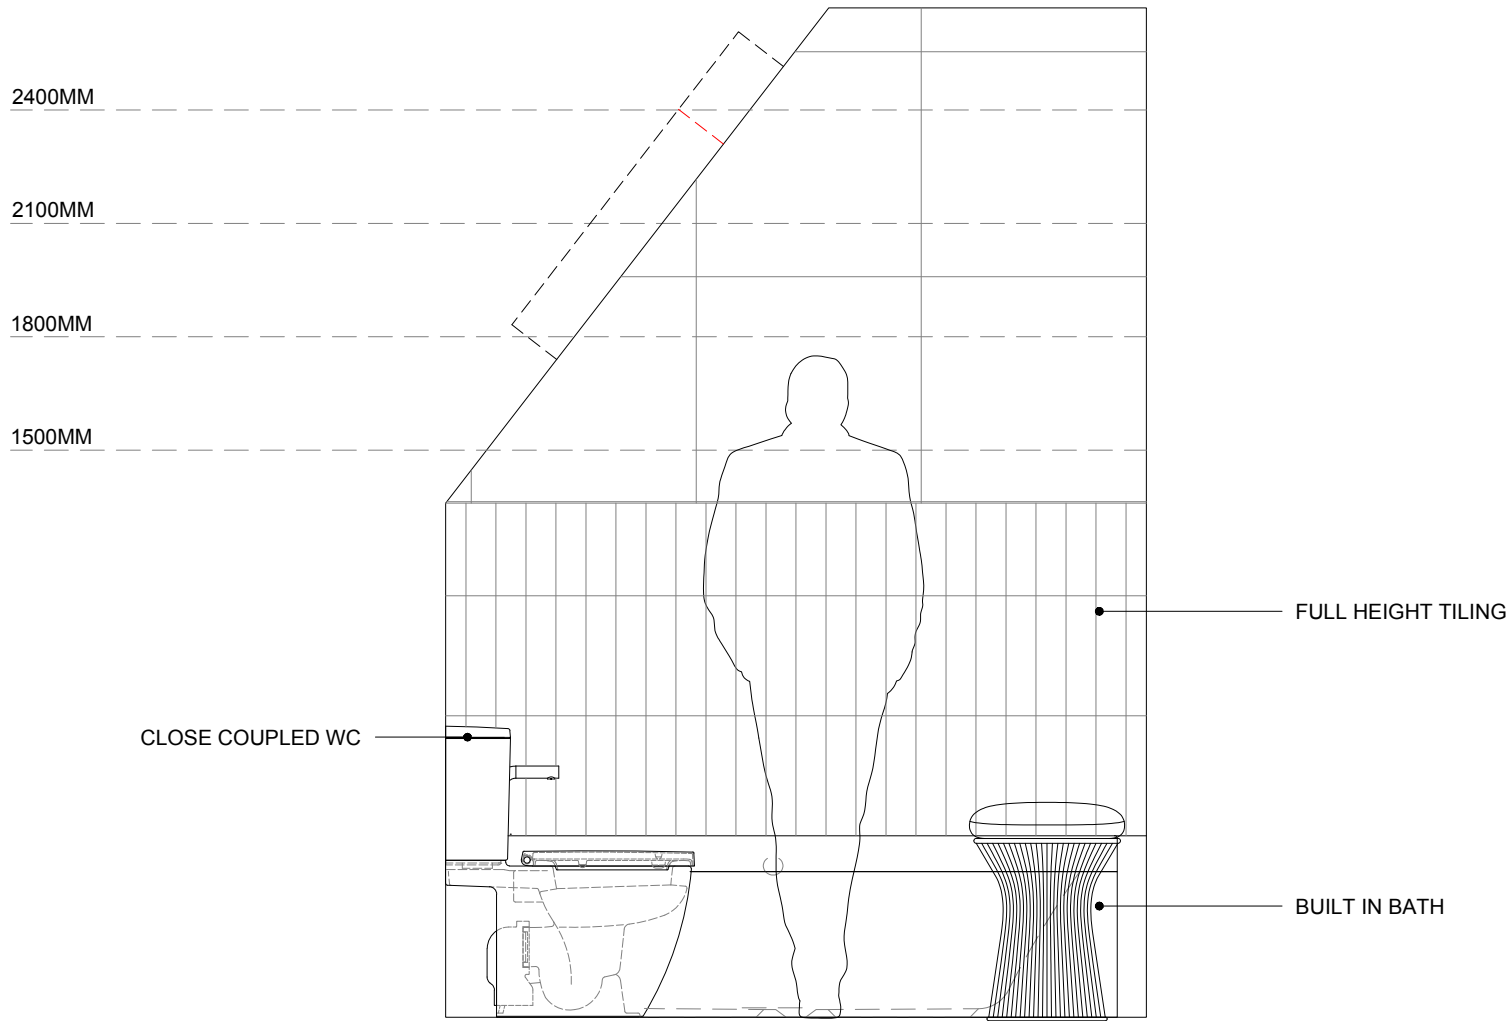


ELEVATION B

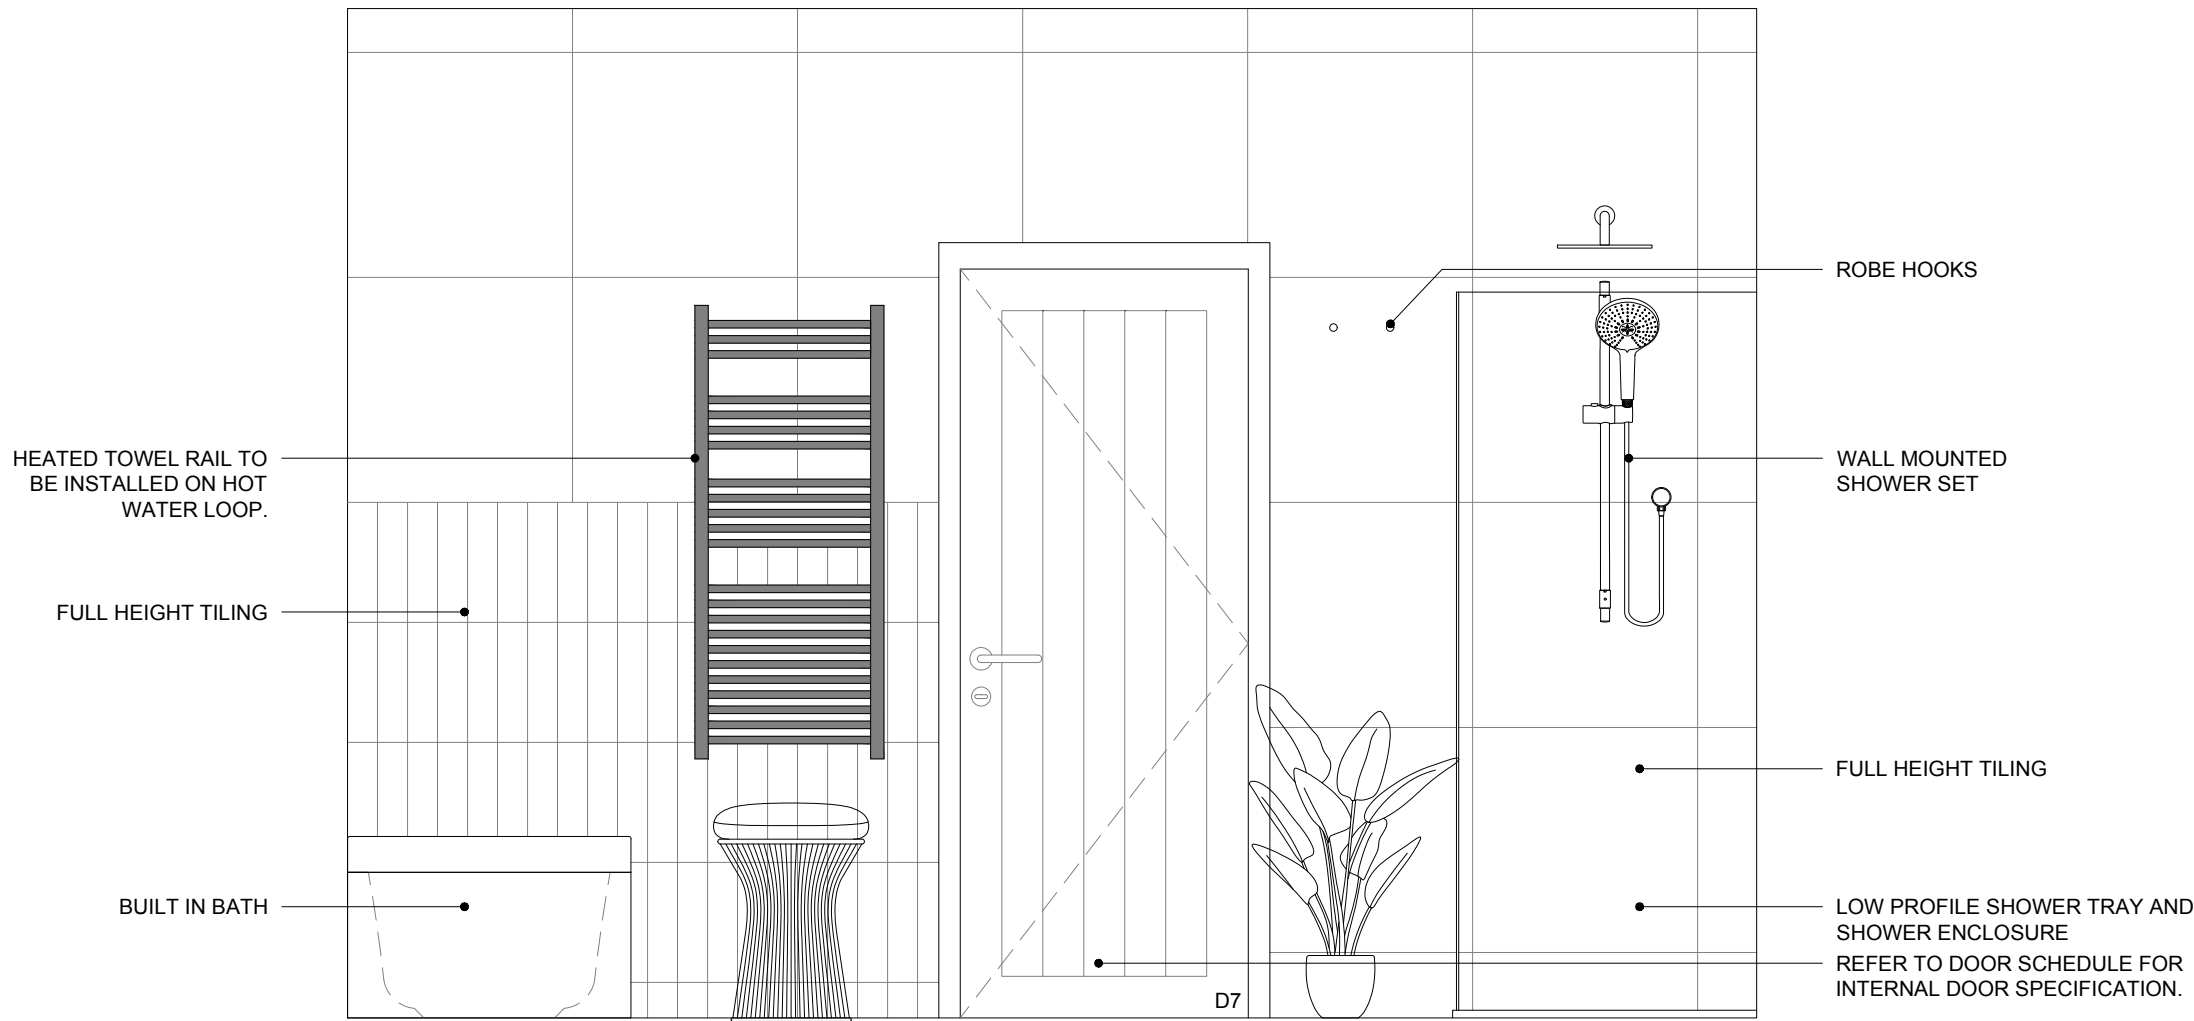


ELEVATION C

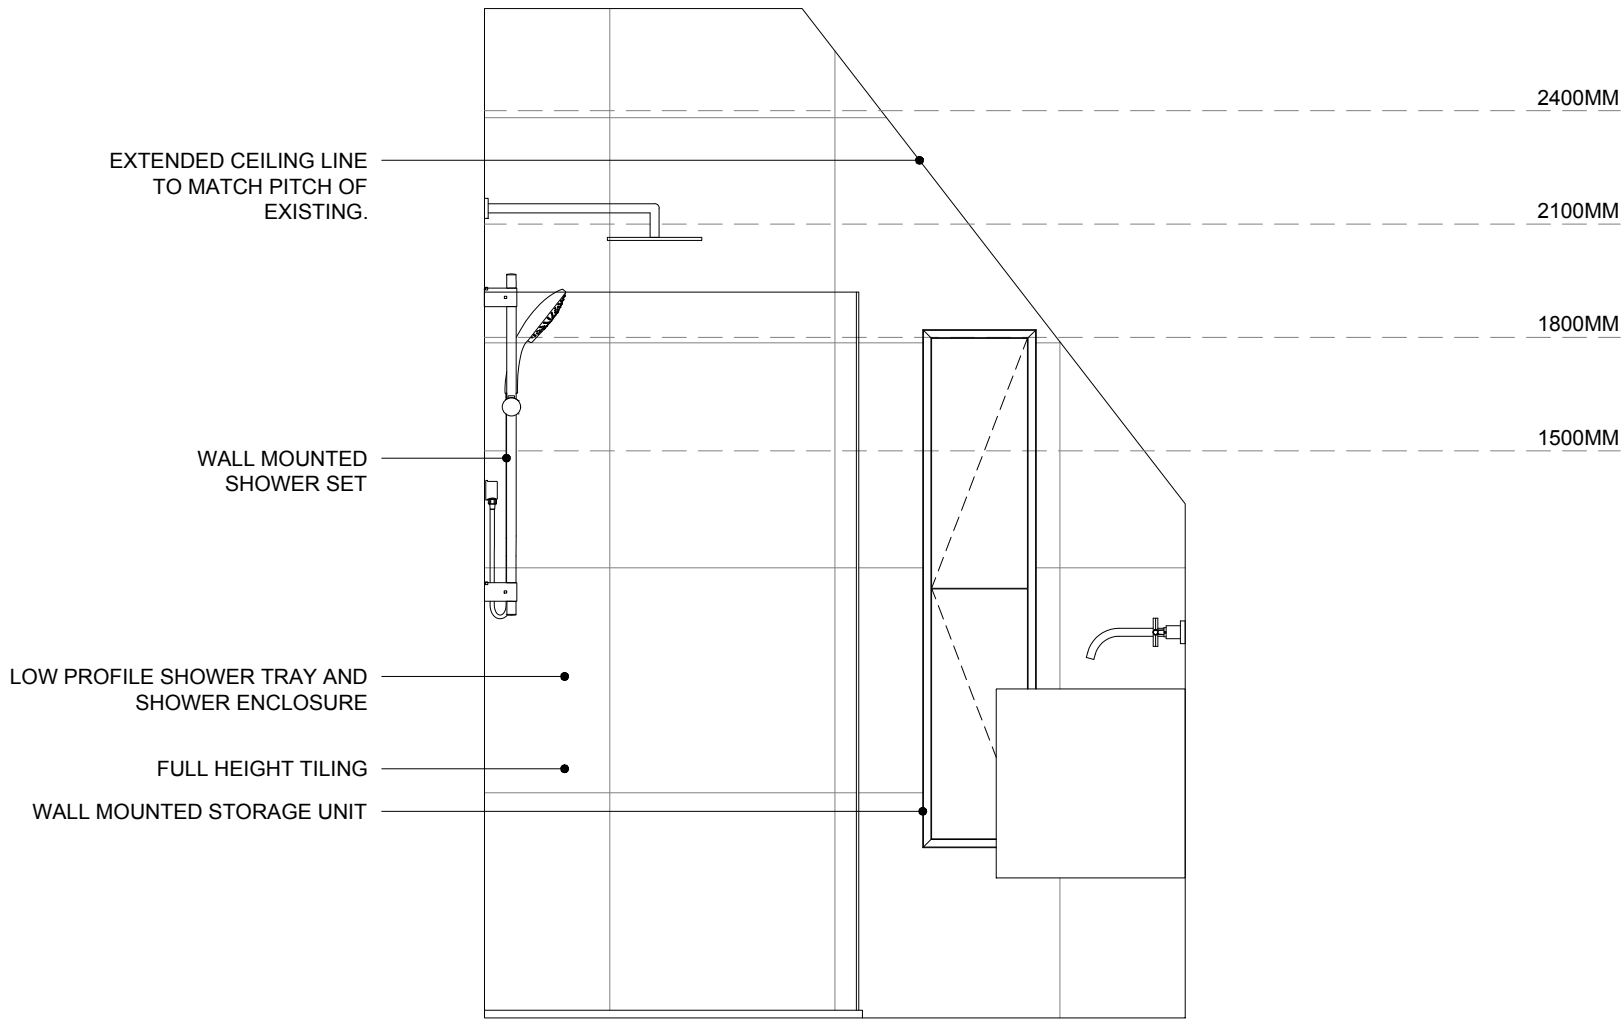

ELEVATION D

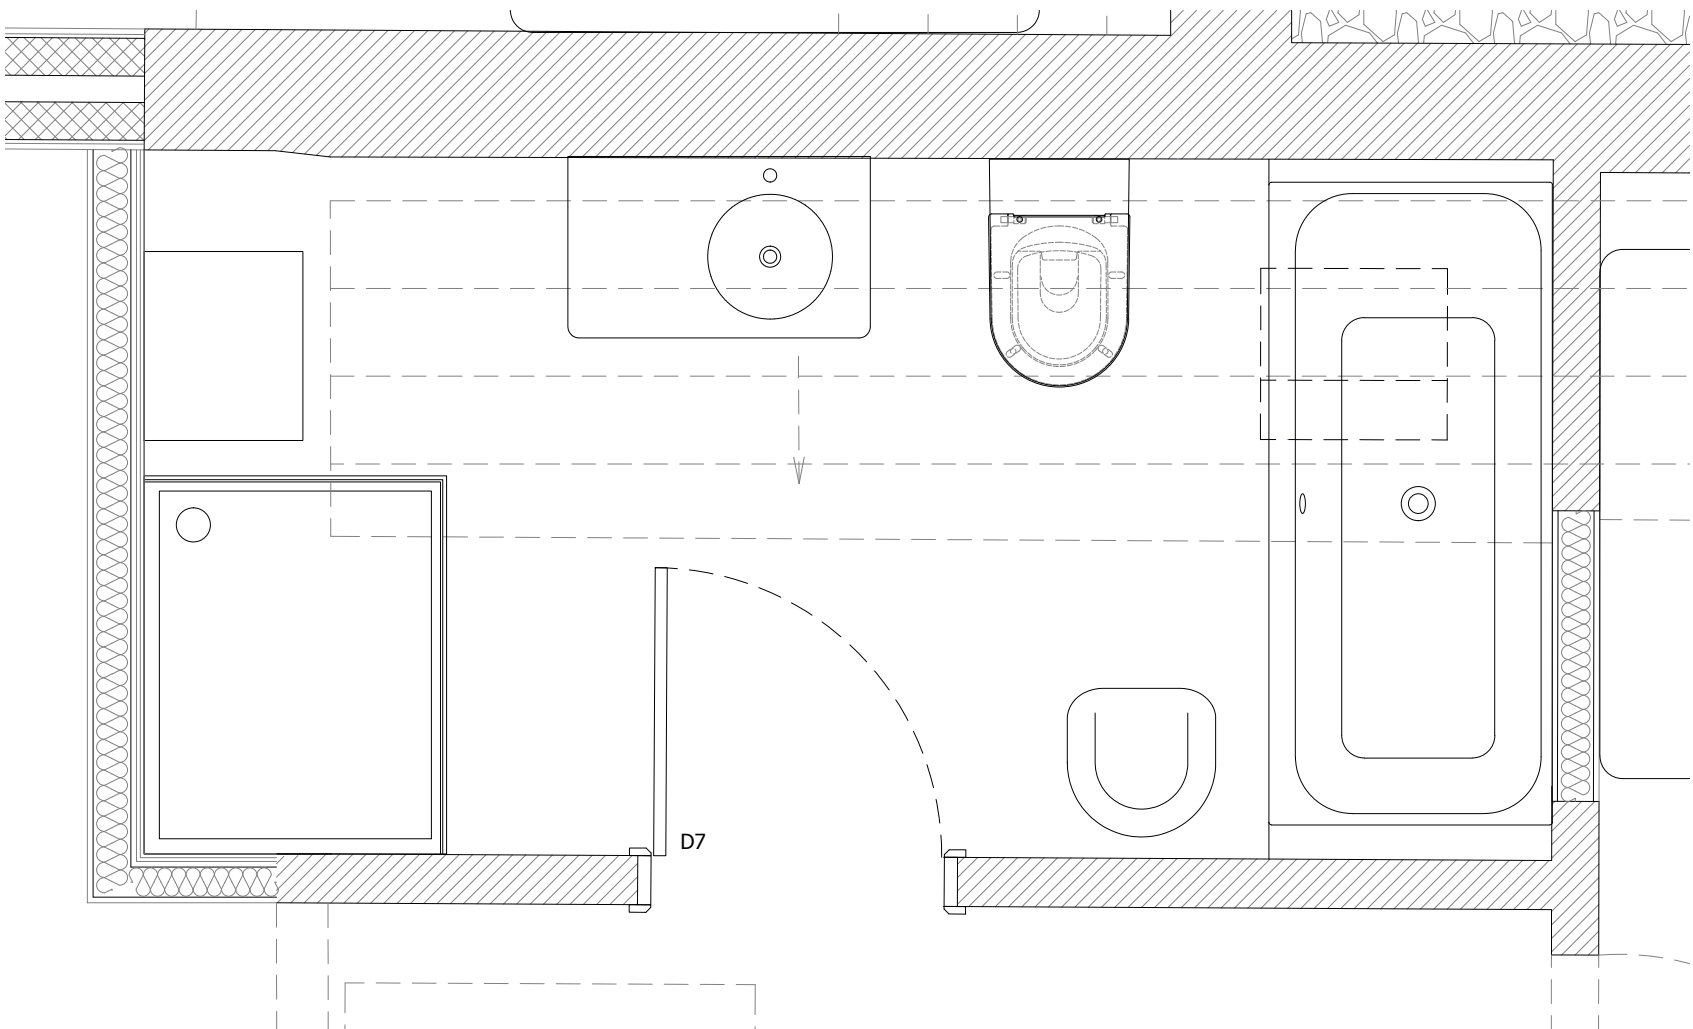

PLAN

 

GENERAL NOTES - DETAILS

- THIS DRAWING IS TO BE READ IN CONJUNCTION WITH ALL GENERAL ARRANGEMENT, PROJECT DETAILS, SPECIFICATIONS AND CONSULTANTS DRAWINGS.
- UNLESS NOTED OTHERWISE, ALL DIMENSIONS ARE TO STRUCTURAL FACES AND/OR PARTITION STUDS.
- ALL ELEMENTS OF WORK TO BE INSTALLED ACCORDING TO THE APPROPRIATE MANUFACTURER'S INSTRUCTIONS.
- ALL EXTERNAL FINISHES TO BE IN ACCORDANCE WITH THE SPECIFICATION AND MATERIAL SCHEDULE.
- MOISTURE RESISTANT BOARD TO BE USED IN ALL BATHROOMS, KITCHENS AND EN-SUITE WET AREAS (GREEN BOARDS).

BUILDING CONTROL

Project	NORTH COTTAGE, READING ROAD, GORING RG8 0LL		
Drawing Title	PROPOSED INTERNAL ELEVATIONS FAMILY BATHROOM		
Date	Scale	Drawn by	Check by
JUNE 22	1:20 @ A1	CA	KB
Project No.	Drawing No.	Revision	
22.134	CO.3301	-	

Fineline
Architects

T. 07825 615 255
E. info@finelinearchitects.co.uk
W. www.finelinearchitects.co.uk