


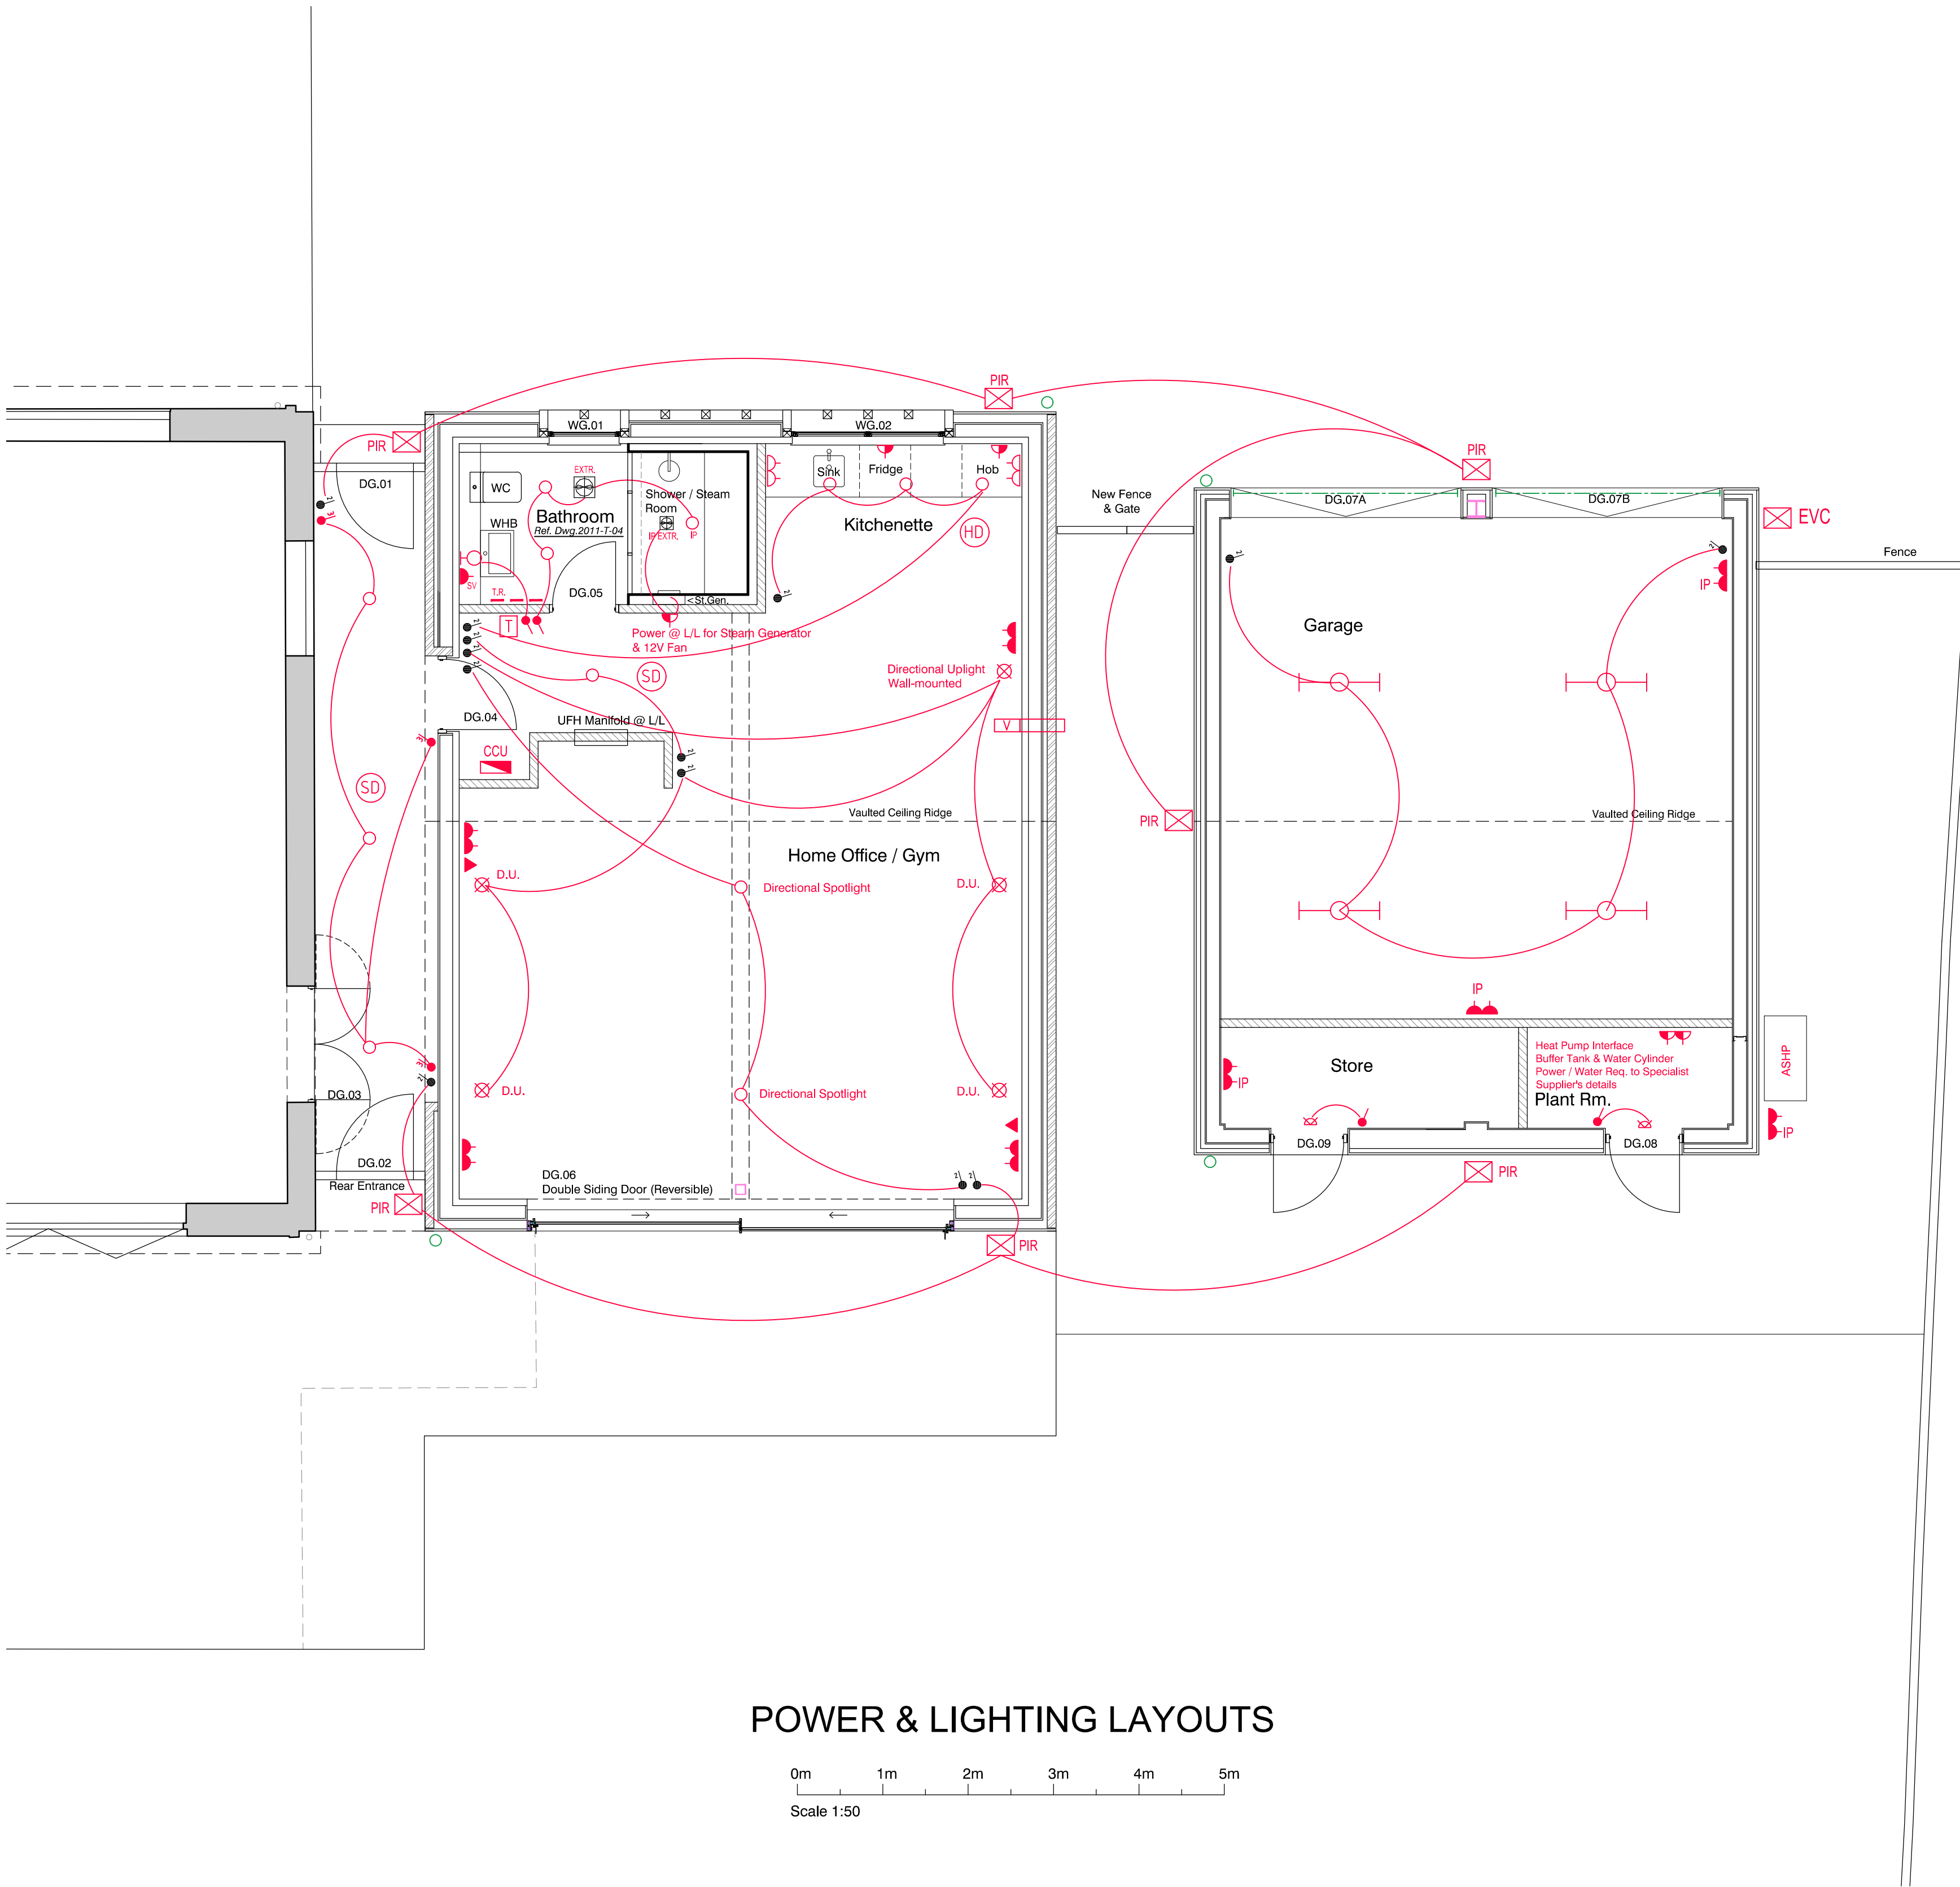

KEY TO ELECTRICAL SYMBOLS					
	Fluorescent tube		Ventilation unit		External IP rated Single switched socket
	Shaver socket		Ventilation control		Single switched socket
	Compact fluorescent timer		Reed Contact		Double switched socket
	Pendant light		TV socket		Double switched socket worktop level
	Wall light		Telephone / Data Ethernet		Single switched socket with 2 USB ports
	External wall light		Extract fan		Double switched socket with 2 USB ports
	External (Security) light		Consumer unit		Double switched socket worktop level with 2 USB ports
	Wall / Ceiling washer		Thermostat & timer		Double switched socket lightswitch level
	Recessed LED downlight		Intruder alarm system		Switch spur
	Pelmet lighting		Security key pad		5 amp light spur low level
	Capsule lighting to front door		Panic Button		EVC Electric Vehicle Charging point
	Bulk head light				
	Radiator				
	Towel rail				

NB: Power requirement for Steam Generator & 12V Fan - TBC with Supplier

Legend

- New walls
- Existing walls
- Existing removed

Survey carried out & drawn by:

74 WATCHET LANE
HOLMER GREEN
HIGH WYCOMBE
BUCKINGHAMSHIRE
HP15 6UG

Tel: 01494 718453
Fax: 01494 717576
e-mail: admin.office@kndsurveys.com

REVISION	DATE	DETAILS
----------	------	---------

DRAWN: NH | CHECKED: NH

HAA take no responsibility for any dimensions obtained by measuring or scaling from this drawing. All dimensions are in millimeters, all levels are in meters, unless otherwise stated. If no dimension is given, ascertain the dimension specifically from the Architect or by site measurement. The sizing of all structural and service elements must always be checked against the relevant engineer's drawings.

ALL COPYRIGHT RESERVED ©

HEIGHWAY ASSOCIATES ARCHITECTS

34 West Street
Marlow
Buckinghamshire
SL7 2NB

01628 483 211
mail@haa-ltd.co.uk

Client: Mr & Mrs M. French

Project: Oak Lodge, West End
Waltham St Lawrence, RG10 0NL

Title: Side Extension & Garage
Power & Lighting Layouts

Issue: Tender
Scale: 1:50 @ A1
Date: January 2024

Drwg No: 2011-T-03 Rev: